


- GENERAL
- CONSTRUCTION SHALL BE IN ACCORDANCE WITH ALL APPLICABLE FEDERAL, STATE OF NEW JERSEY, AND TOWNSHIP OF NEPTUNE CODES AND ORDINANCES (IBC2021), INCLUDING FIRE CODES.
  - THIS STRUCTURE IS CLASSIFIED AS A MIXED USE, AN OPEN PARKING STRUCTURE, OCCUPANCY GROUP S-2, CUP, OCCUPANCY GROUP F-1. THE STRUCTURE IS CONSTRUCTION TYPE IA, NON-COMBUSTIBLE.


| PARKING SCHEDULE - OVERALL |          |            |       |
|----------------------------|----------|------------|-------|
| TIER                       | STANDARD | ACCESSIBLE | TOTAL |
| GROUND                     | 54       | 4*         | 58    |
| SECOND                     | 123      | 2          | 125   |
| THIRD                      | 131      | 2          | 133   |
| FOURTH                     | 123      | 2          | 125   |
| FIFTH                      | 155      | 2          | 157   |
| SIXTH                      | 155      | 2          | 157   |
| SEVENTH                    | 146      | 3          | 149   |
| EIGHTH                     | 155      | 2          | 157   |
| NINTH                      | 155      | 2          | 157   |
| TOP                        | 47       | 3          | 50    |
| SUM                        | 1244     | 24         | 1268  |

- (36) DUAL EV CHARGERS FOR (72) EV CHARGING STALLS ALLOCATED.  
LOCATIONS TBD.  
- (4) ADA VAN

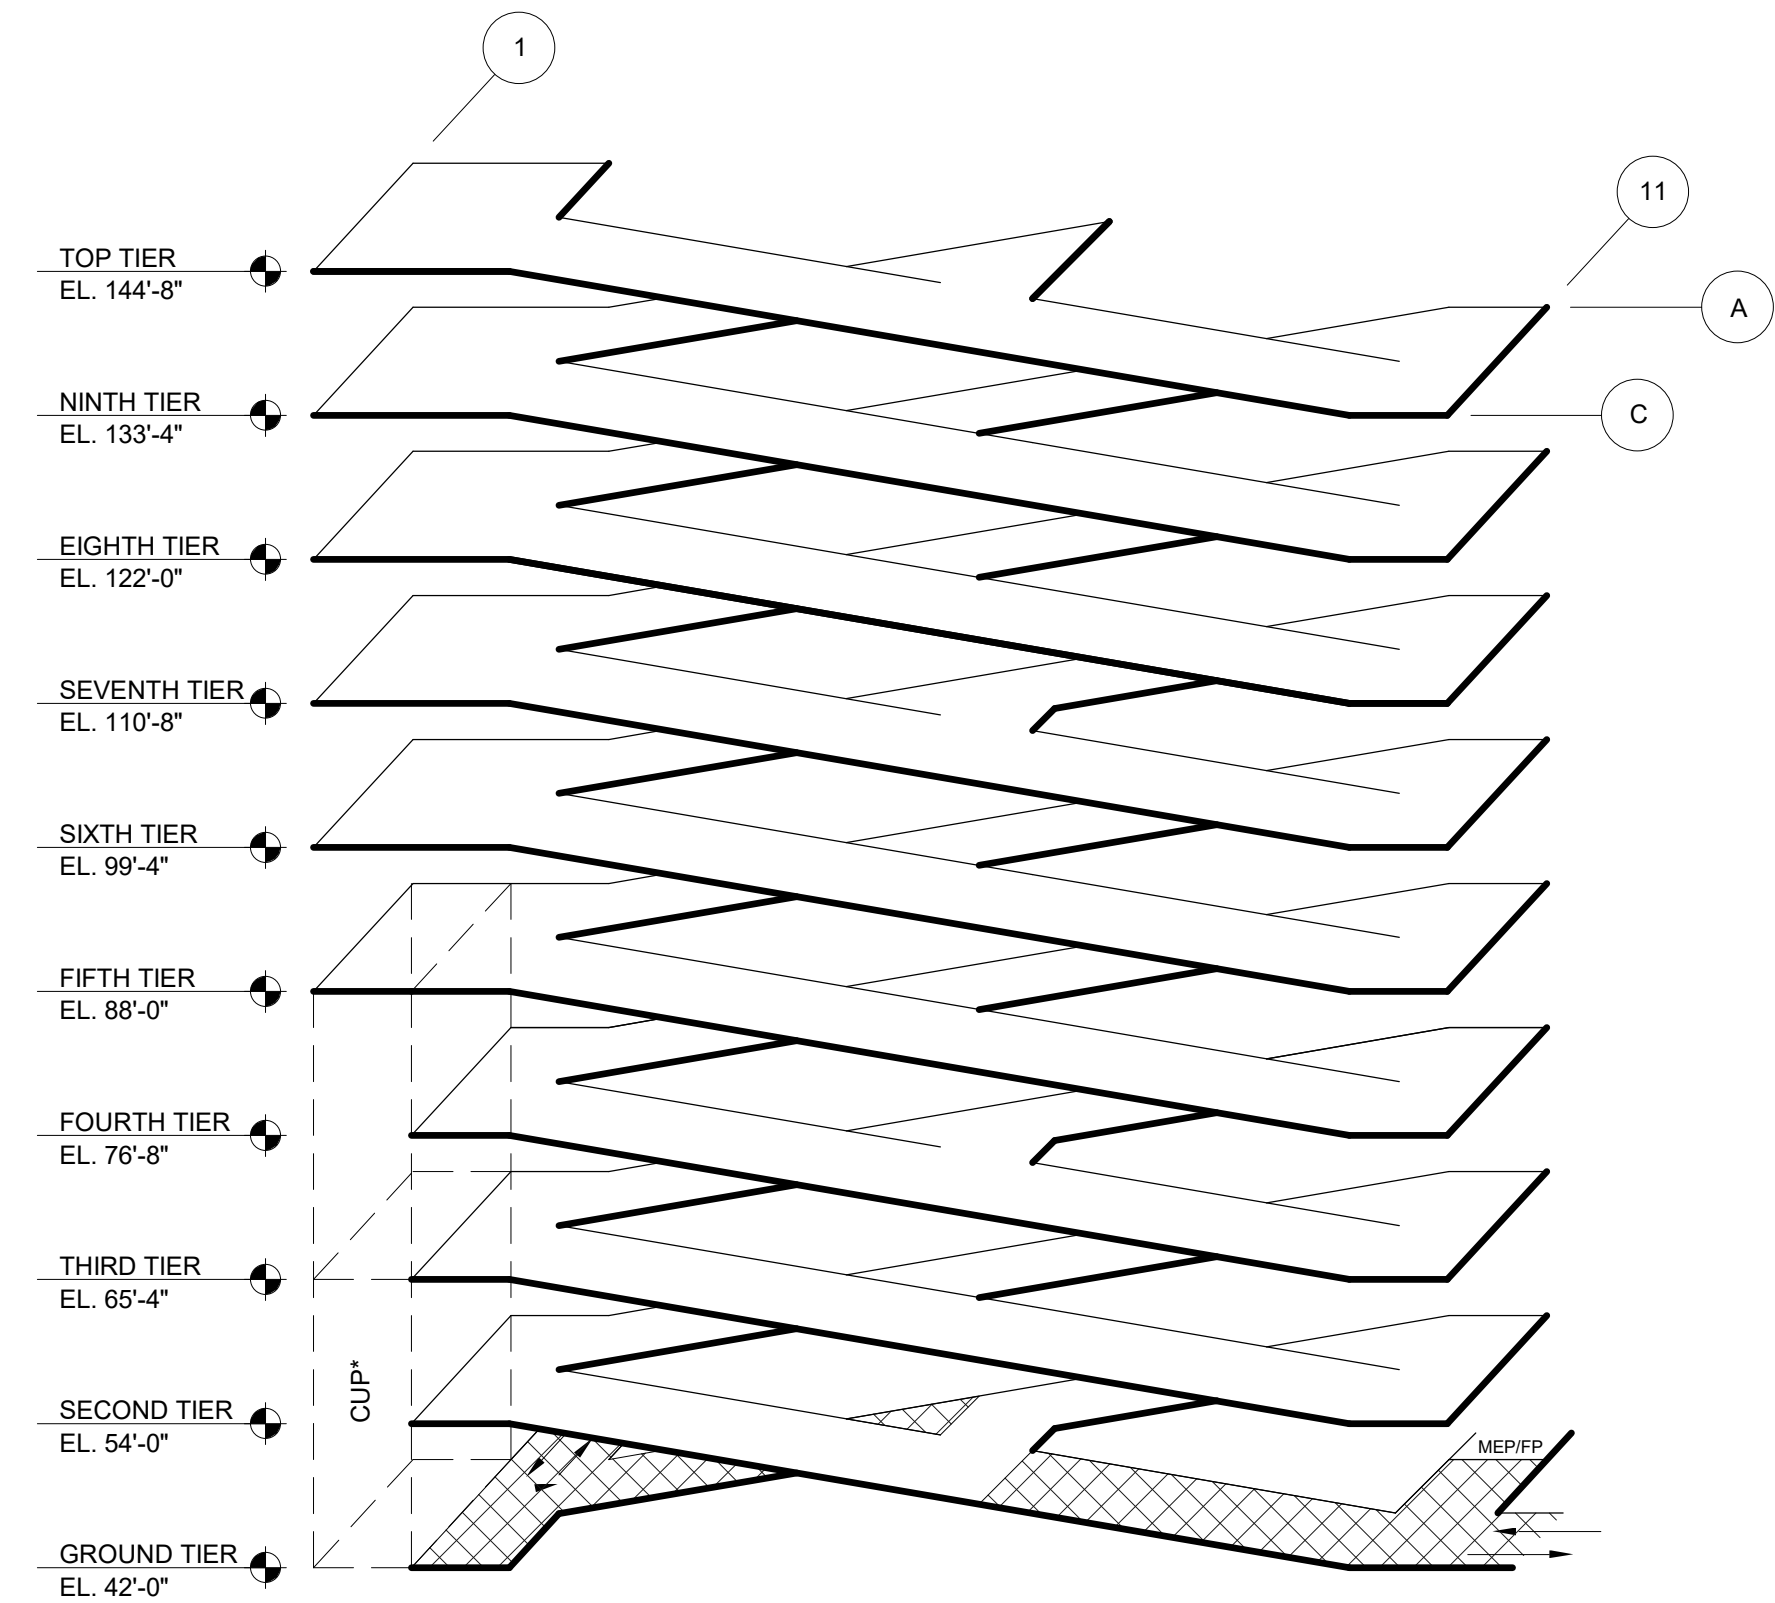

\*CUP: CENTRAL UTILITY PLANT

ISOMETRIC

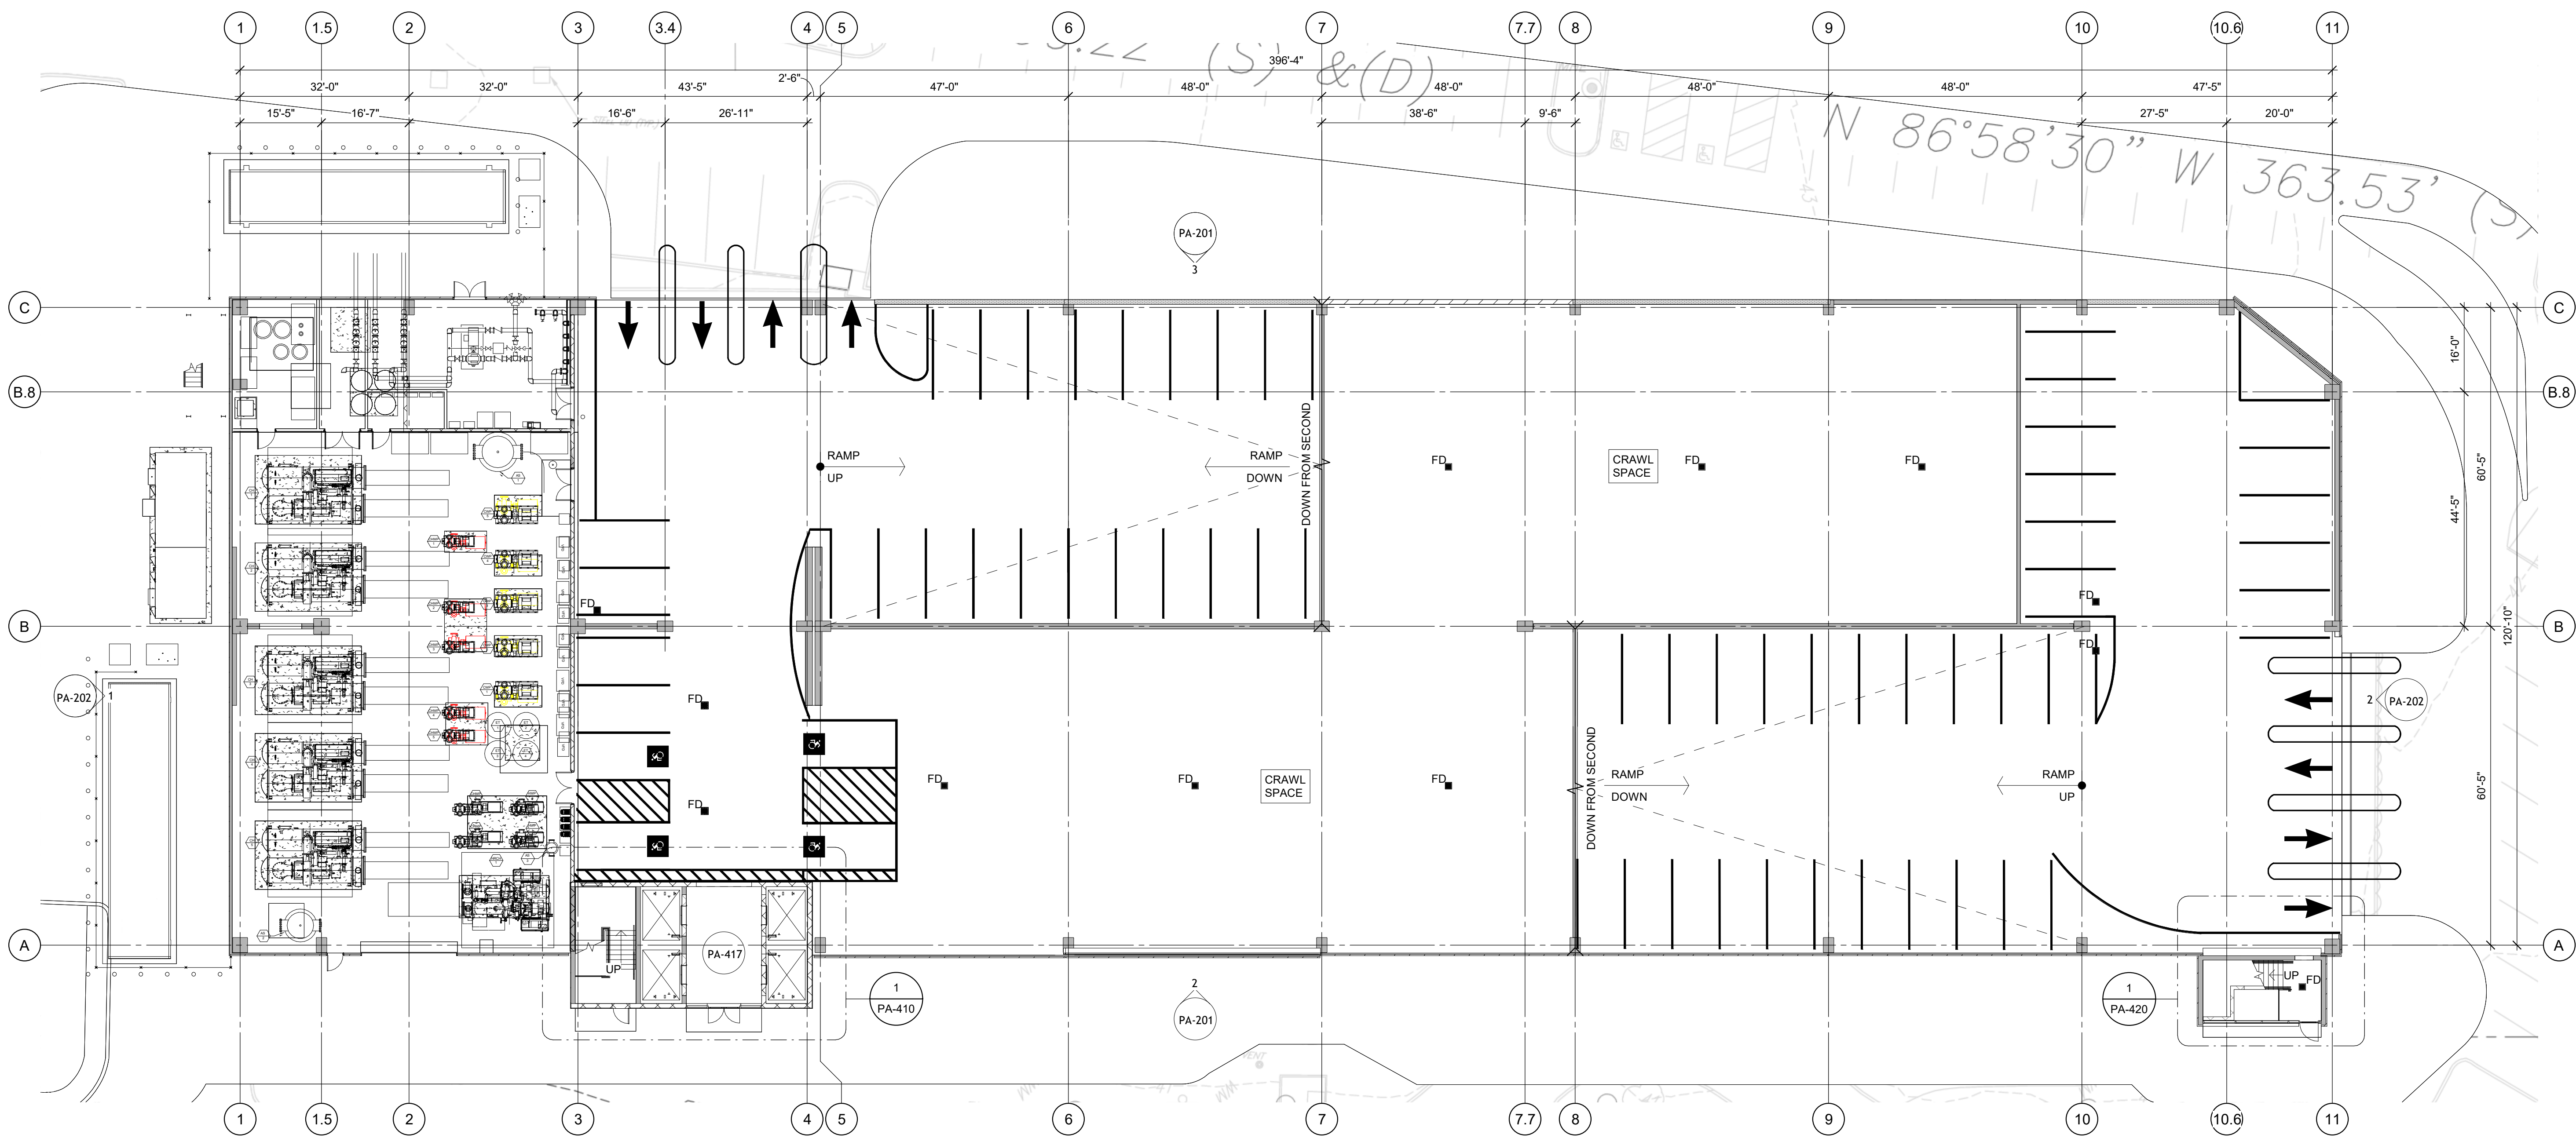

1 GROUND TIER PLAN  
1/16" = 1'-0"

## SHEET NOTES

- INDICATES PLAN MATCH LINE.
- ALL DIMENSIONS FOR STRIPING ARE FROM FACE OF COLUMN OR INSIDE FACE OF WALL UNO.
- FOR BUILDING ELEVATIONS SEE "PA-200" SERIES DRAWINGS.



49 West 38th St, 9th Floor  
New York, NY 10018  
212.286.2501 Ph  
www.walkerconsultants.com


SCOTT ASHLEY, PE  
EOR LICENSE NO: 24GE05535400

PRELIMINARY - DO NOT USE FOR CONSTRUCTION

JSUMC-Neptune Garage  
Jersey Shore University  
Medical Center  
81 DAVIS AVENUE  
TOWNSHIP OF NEPTUNE  
MONMOUTH COUNTY, NJ

## LEGEND

- CIP
- CIP (PLAN CUT)
- PRECAST CONCRETE
- CMU
- CIP POUR STRIP
- TRAFFIC TOPPING
- PAVEMENT MARKING - NO PARKING AREA
- SHEET NOTE
- FIRE EXTINGUISHER CABINET
- PIPE BOLLARD
- V1
- OR
- FLOOR DRAIN
- FLEXIBLE DELINEATOR POST
- EMERGENCY CALL STATION

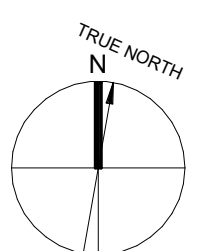


| MARK      | DATE       | DESCRIPTION    |
|-----------|------------|----------------|
| REVISIONS |            |                |
| 1         | 02/06/2025 | PLANNING BOARD |

ISSUE DATE: 02/06/2025  
PROJECT NO: 18-002290.00  
DRAWN BY: C.LUIS  
CHECKED BY: L.GE


COPYRIGHT © 2024. ALL RIGHTS RESERVED. NO PART OF THIS DOCUMENT MAY BE REPRODUCED IN ANY FORM OR BY ANY MEANS WITHOUT PERMISSION FROM WALKER CONSULTANTS.

SHEET TITLE:  
GROUND TIER PLAN

PA-101

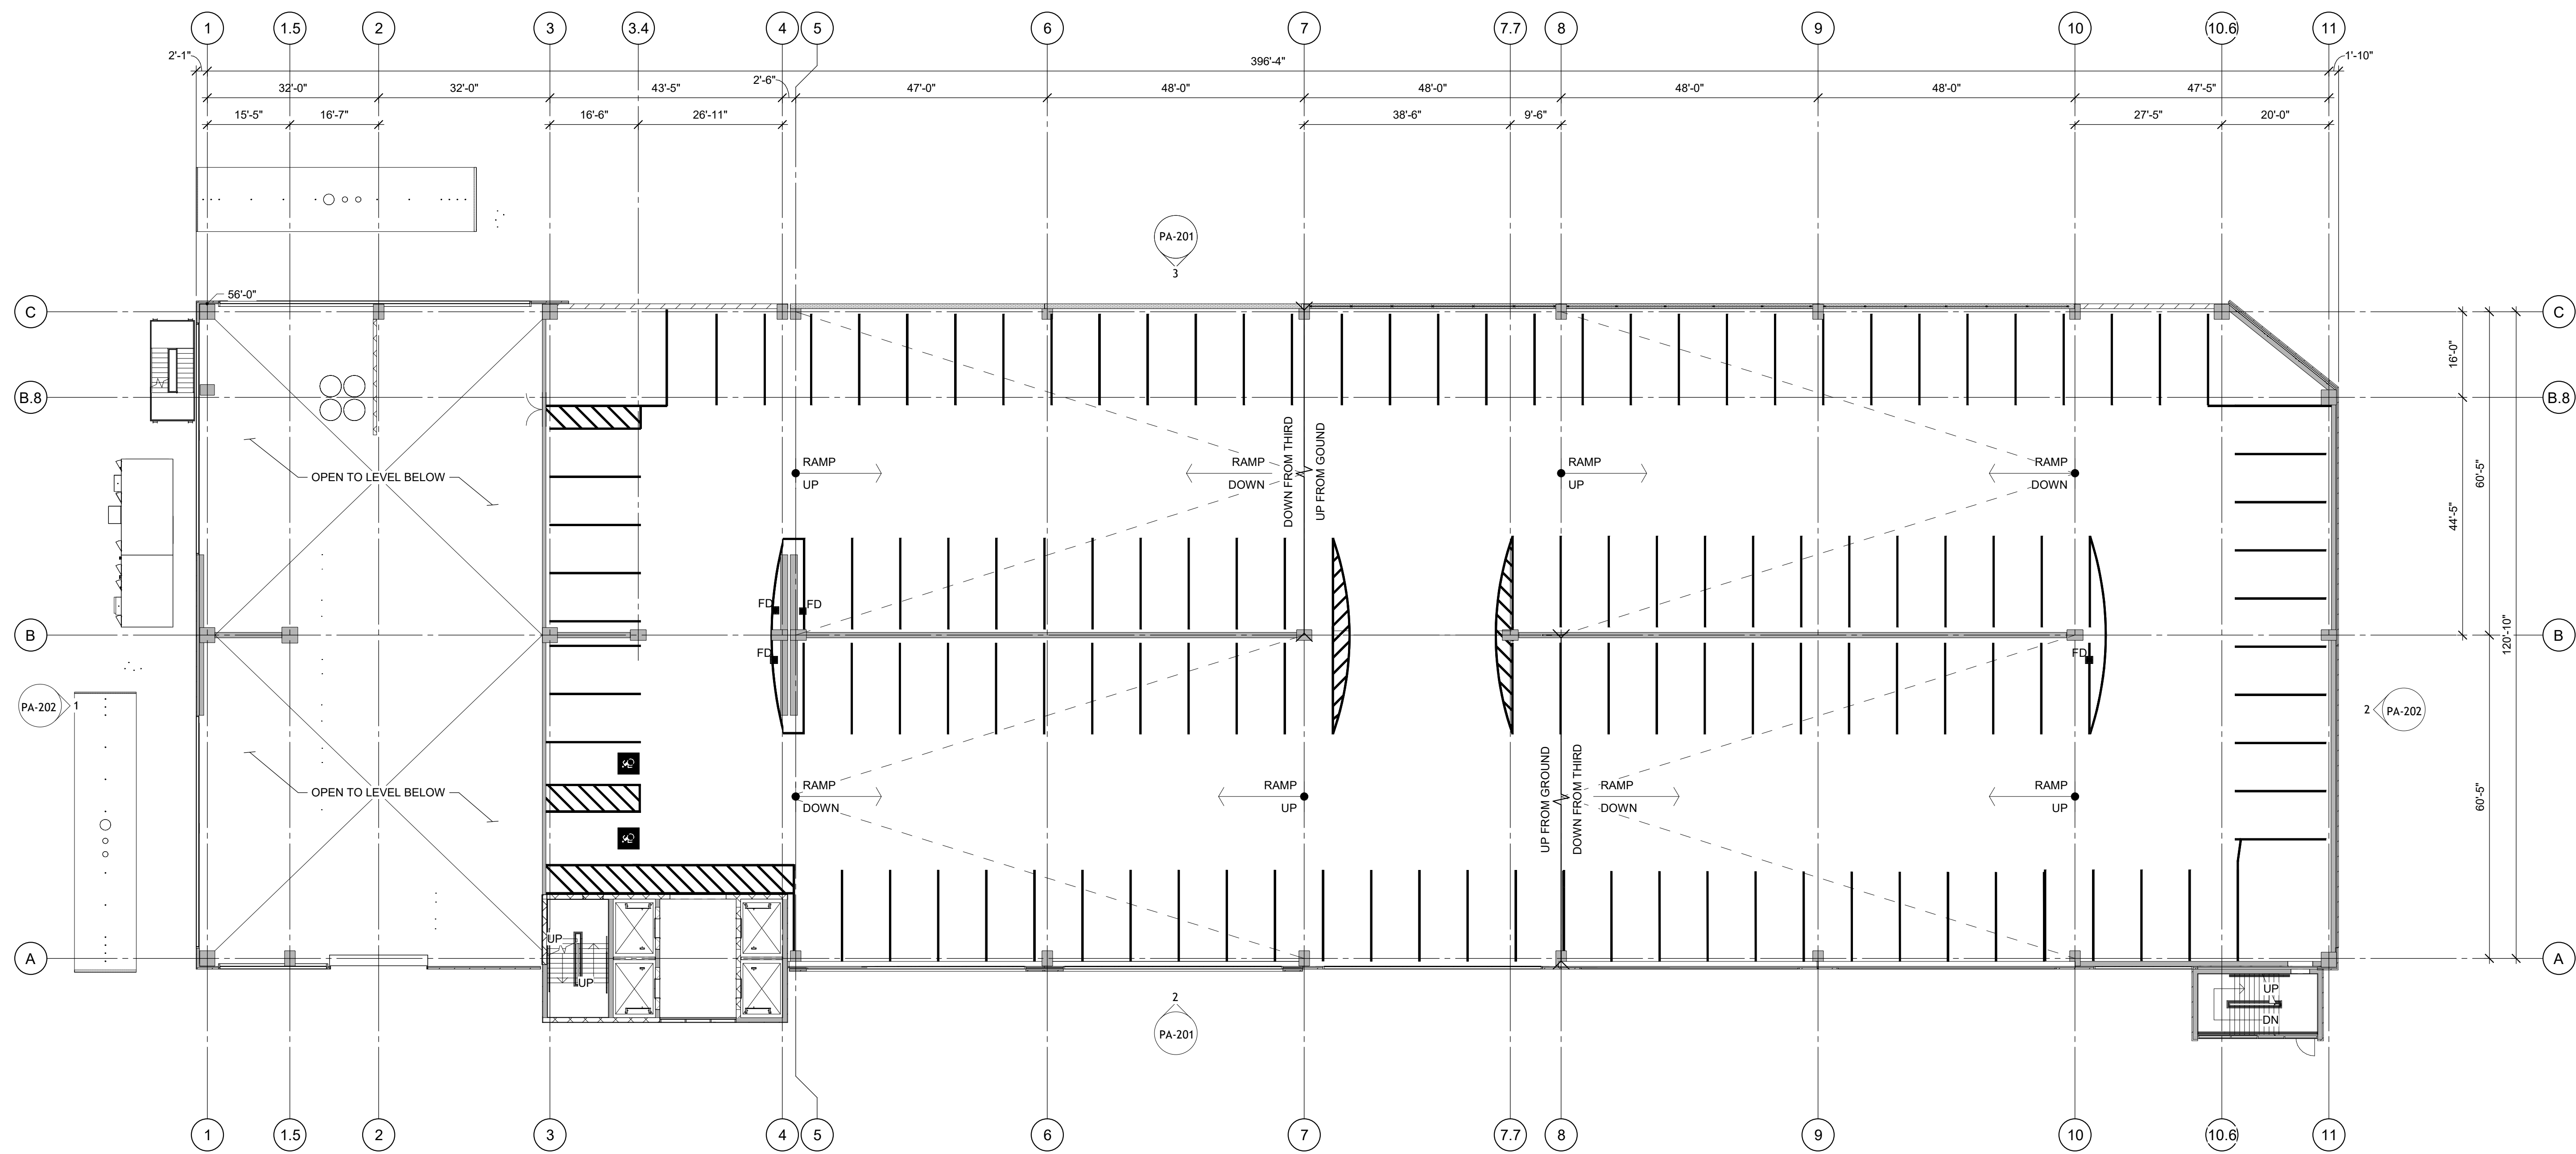

1 SECOND TIER PLAN  
1/16" = 1'-0"

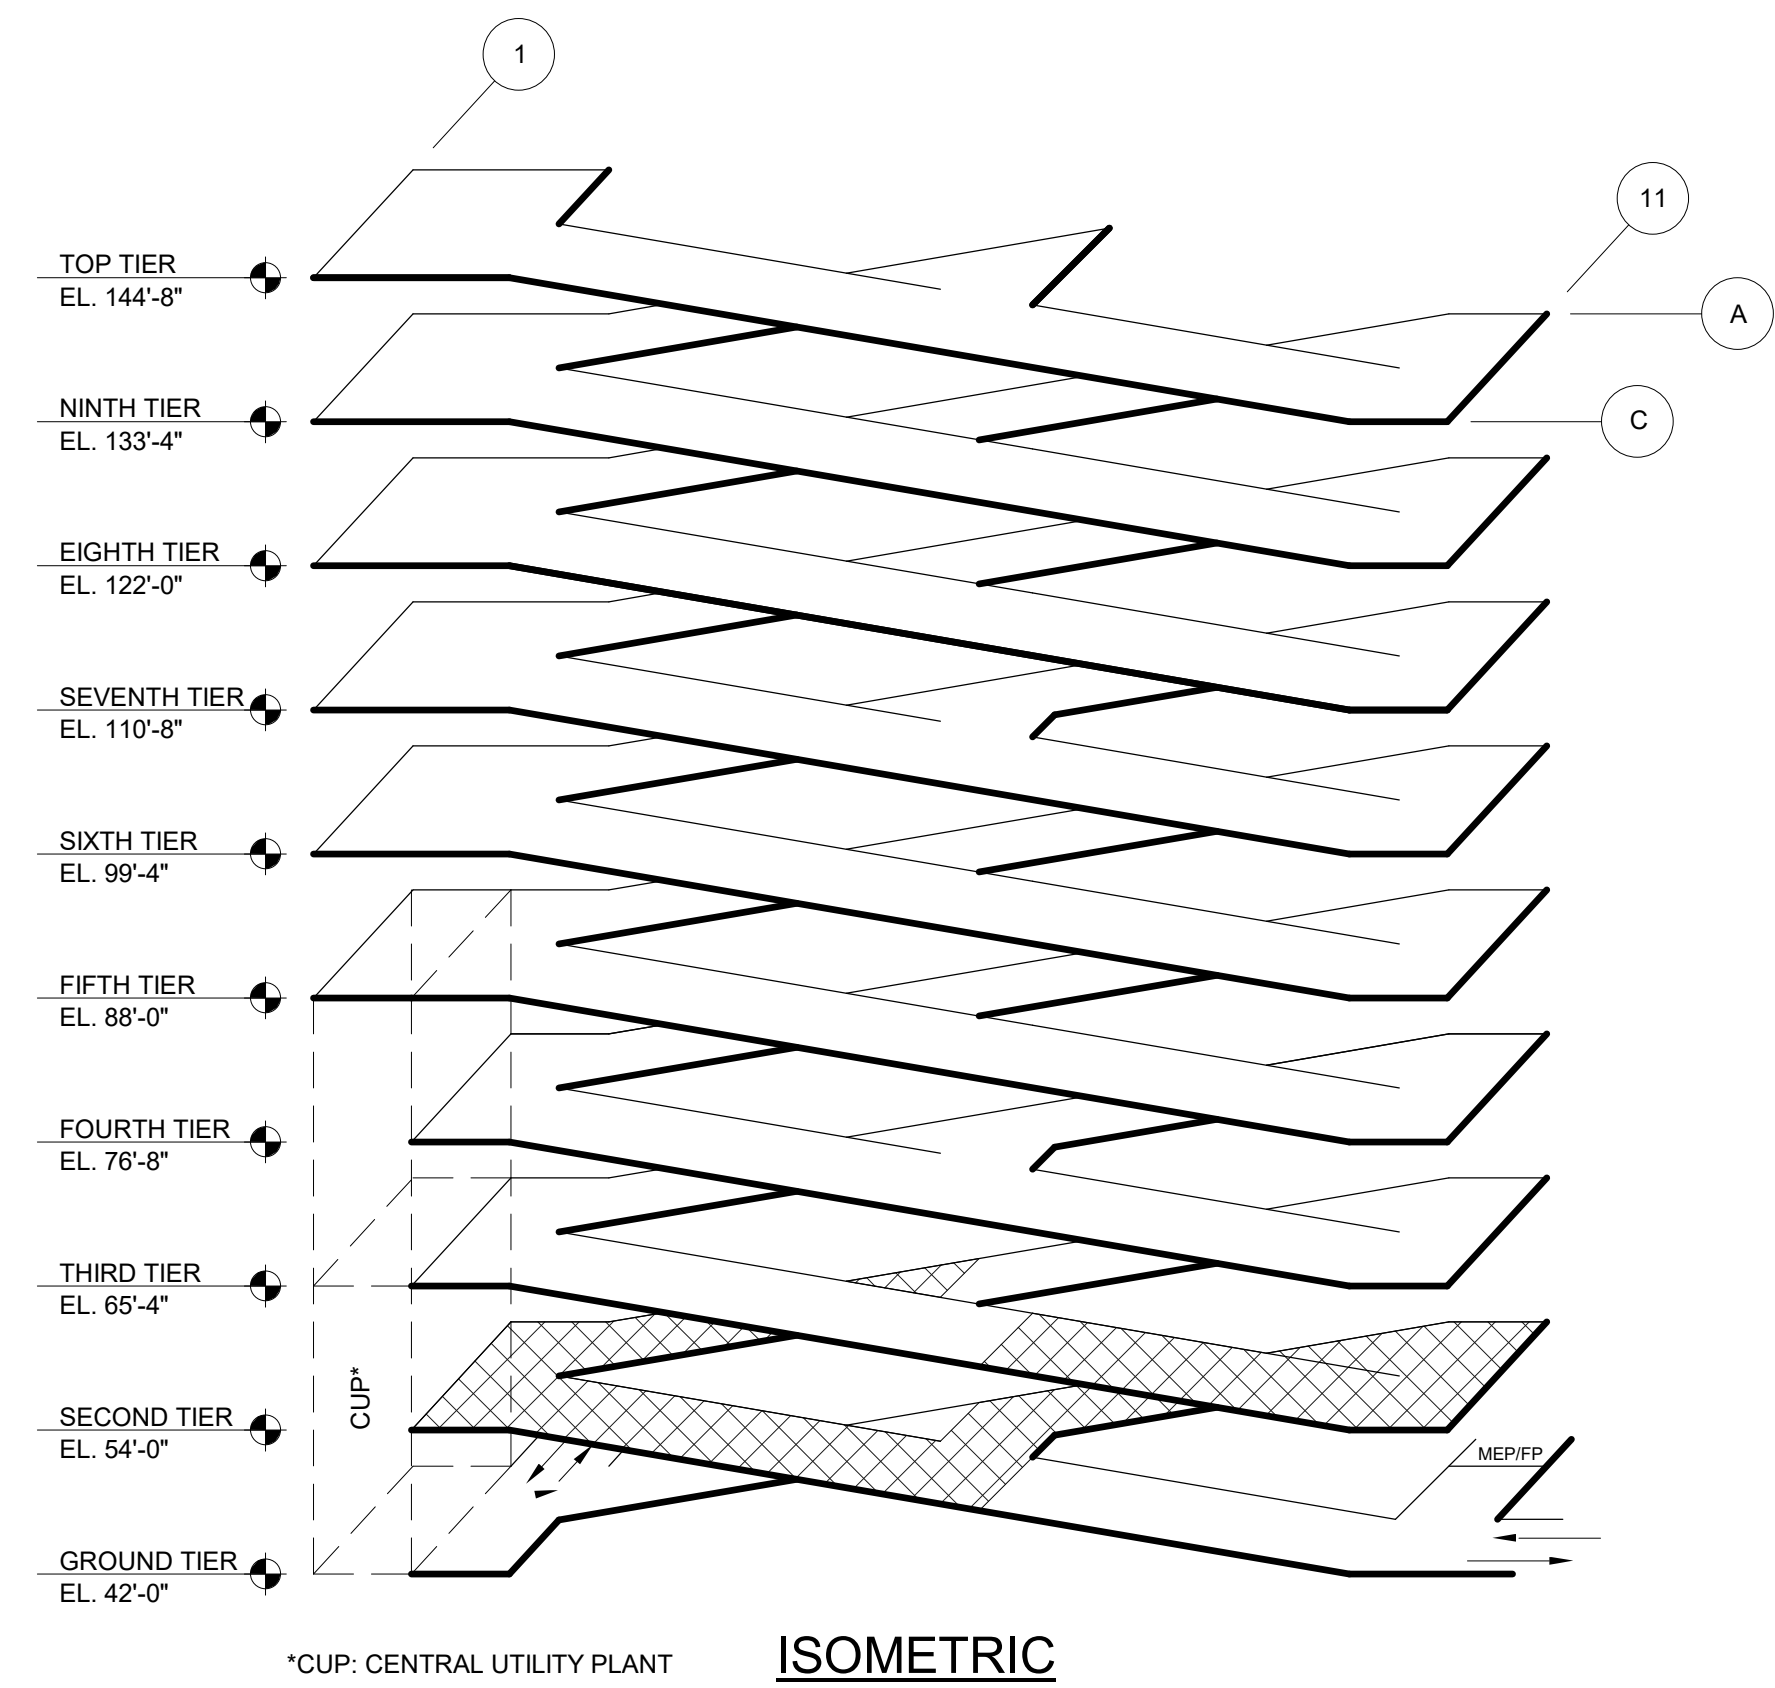

SHEET NOTES

PRELIMINARY - DO NOT USE FOR CONSTRUCTION

LEGEND

- CIP
- CIP (PLAN CUT)
- PRECAST CONCRETE
- CMU
- CIP POUR STRIP
- TRAFFIC TOPPING
- PAVEMENT MARKING - NO PARKING AREA
- SHEET NOTE
- FIRE EXTINGUISHER CABINET
- PIPE BOLLARD
- SIGN LEGEND
- FLOOR DRAIN
- FLEXIBLE DELINEATOR POST
- EMERGENCY CALL STATION

JSUMC-Neptune Garage  
Jersey Shore University  
Medical Center  
81 DAVIS AVENUE  
TOWNSHIP OF NEPTUNE  
MONMOUTH COUNTY, NJ


| MARK      | DATE       | DESCRIPTION    |
|-----------|------------|----------------|
| REVISIONS |            |                |
| 1         | 02/06/2025 | PLANNING BOARD |

ISSUE DATE: 02/06/2025  
PROJECT NO: 18-002290.00  
DRAWN BY: C.LUIS  
CHECKED BY: L.GE


COPYRIGHT © 2024. ALL RIGHTS RESERVED. NO PART OF THIS DOCUMENT MAY BE REPRODUCED IN ANY FORM OR BY ANY MEANS WITHOUT PERMISSION FROM WALKER CONSULTANTS.

SHEET TITLE:  
SECOND TIER PLAN

2/25/2025 3:01:00 PM Autocad Doc: /18-022290.00 JSUMC-Neptune Design-Build/2290\_NJ\_Neptune\_Garage\_Struct\_R04.rvt

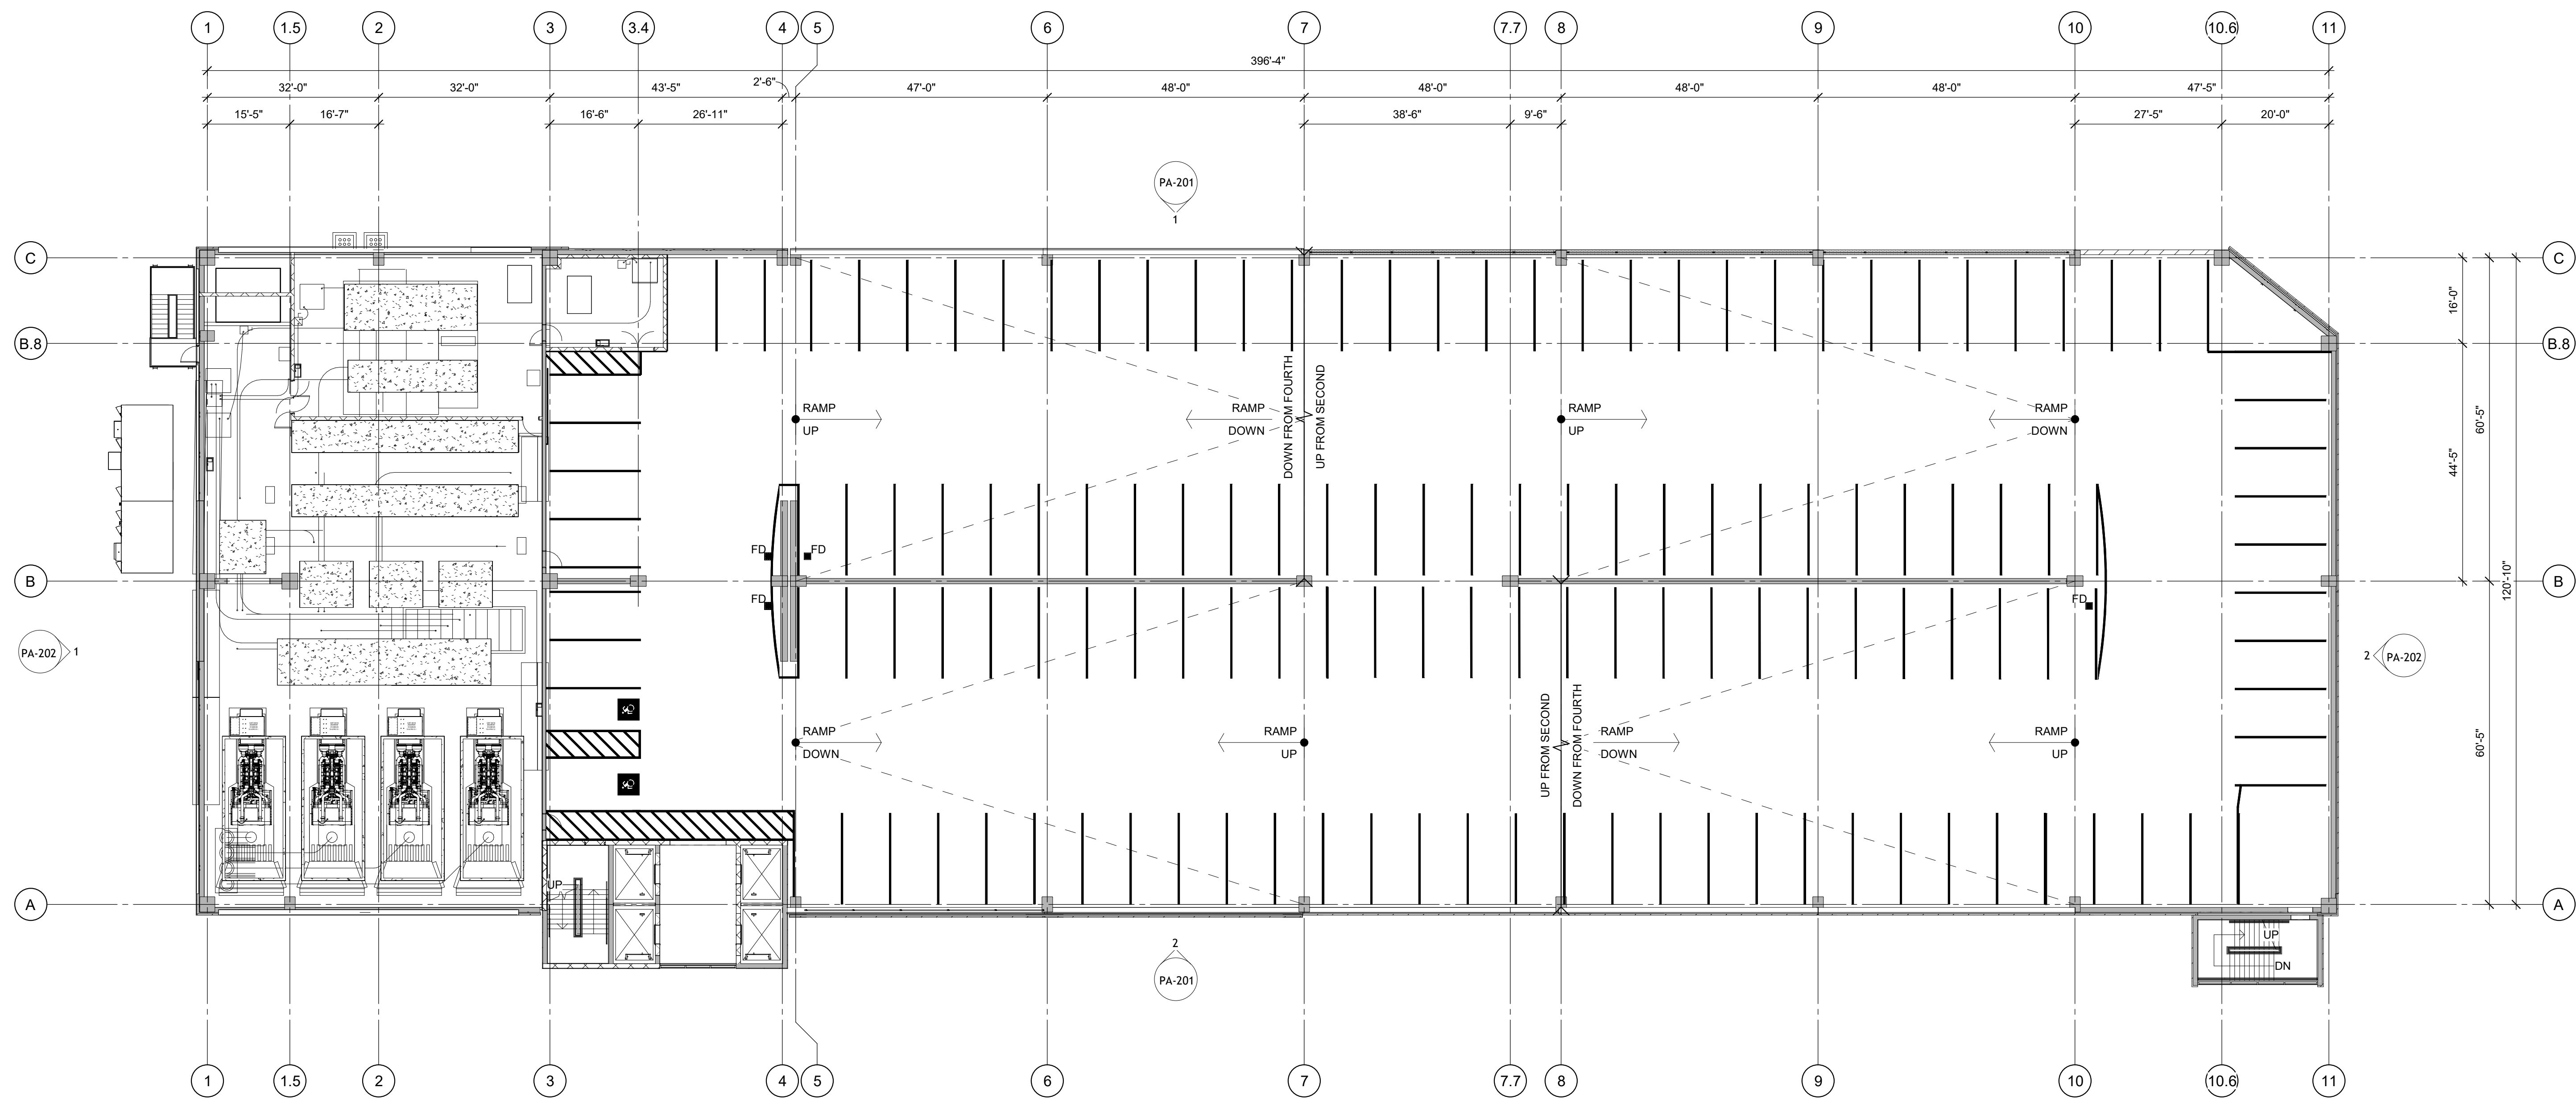

1 THIRD TIER PLAN  
1/16" = 1'-0"

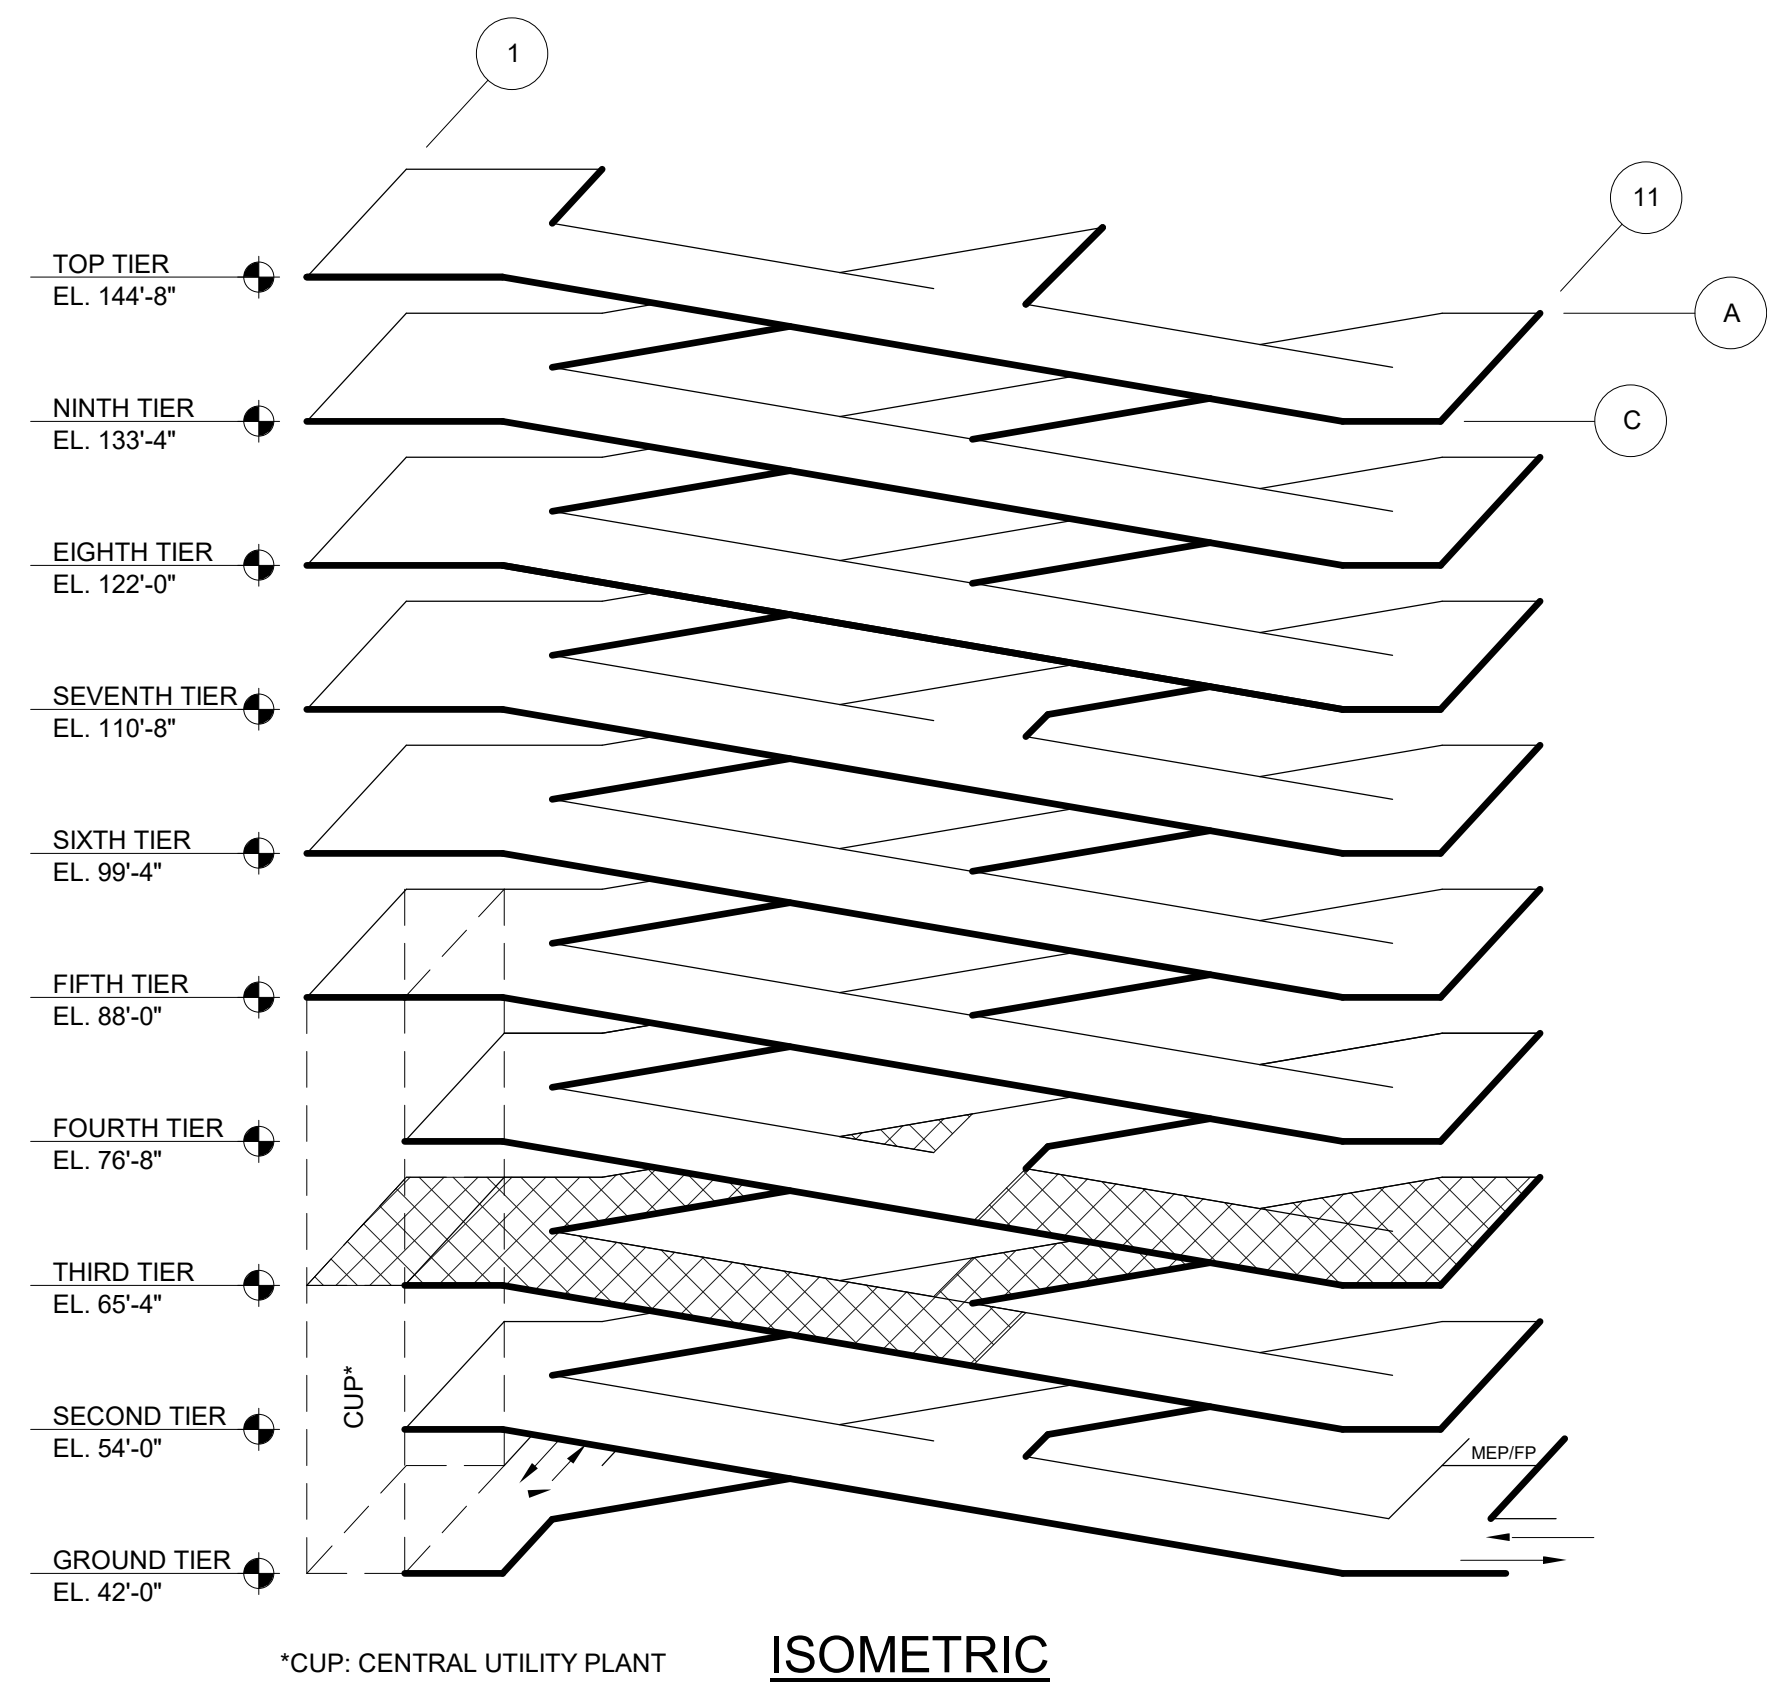

## SHEET NOTES

1. SEE SHEET PA-100 FOR TYPICAL SHEET NOTES AND LOCATIONS OF TYPICAL DETAIL REFERENCES, UN.




49 West 38th St, 9th Floor  
New York, NY 10018  
212.286.2501 Ph  
www.walkerconsultants.com

SCOTT ASHLEY, PE  
EOR LICENSE NO: 24GE05535400

PRELIMINARY - DO NOT USE FOR CONSTRUCTION

## LEGEND

- CIP
- CIP (PLAN CUT)
- PRECAST CONCRETE
- CMU
- CIP POUR STRIP
- TRAFFIC TOPPING
- PAVEMENT MARKING - NO PARKING AREA
- SHEET NOTE
- FIRE EXTINGUISHER CABINET
- PIPE BOLLARD
- SIGN LEGEND
- FLOOR DRAIN
- FLEXIBLE DELINEATOR POST
- EMERGENCY CALL STATION

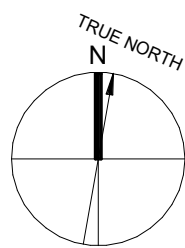

JSUMC-Neptune Garage  
Jersey Shore University  
Medical Center  
81 DAVIS AVENUE  
TOWNSHIP OF NEPTUNE  
MONMOUTH COUNTY, NJ


| MARK                     | DATE | DESCRIPTION    |
|--------------------------|------|----------------|
| REVISIONS                |      |                |
| 1                        |      | PLANNING BOARD |
| ISSUE DATE: 02/06/2025   |      |                |
| PROJECT NO: 18-002290.00 |      |                |
| DRAWN BY: C.LUIS         |      |                |
| CHECKED BY: L.GE         |      |                |

COPYRIGHT © 2024. ALL RIGHTS RESERVED. NO PART OF THIS DOCUMENT MAY BE REPRODUCED IN ANY FORM OR BY ANY MEANS WITHOUT PERMISSION FROM WALKER CONSULTANTS.


SHEET TITLE  
THIRD TIER PLAN

PA-103

2/5/2025 3:01:03 PM Autodesk Docs://18-002290.00 JSUMC-Neptune Design-Build/2290\_NJ\_Neptune\_Garage\_Struct\_R04.rvt

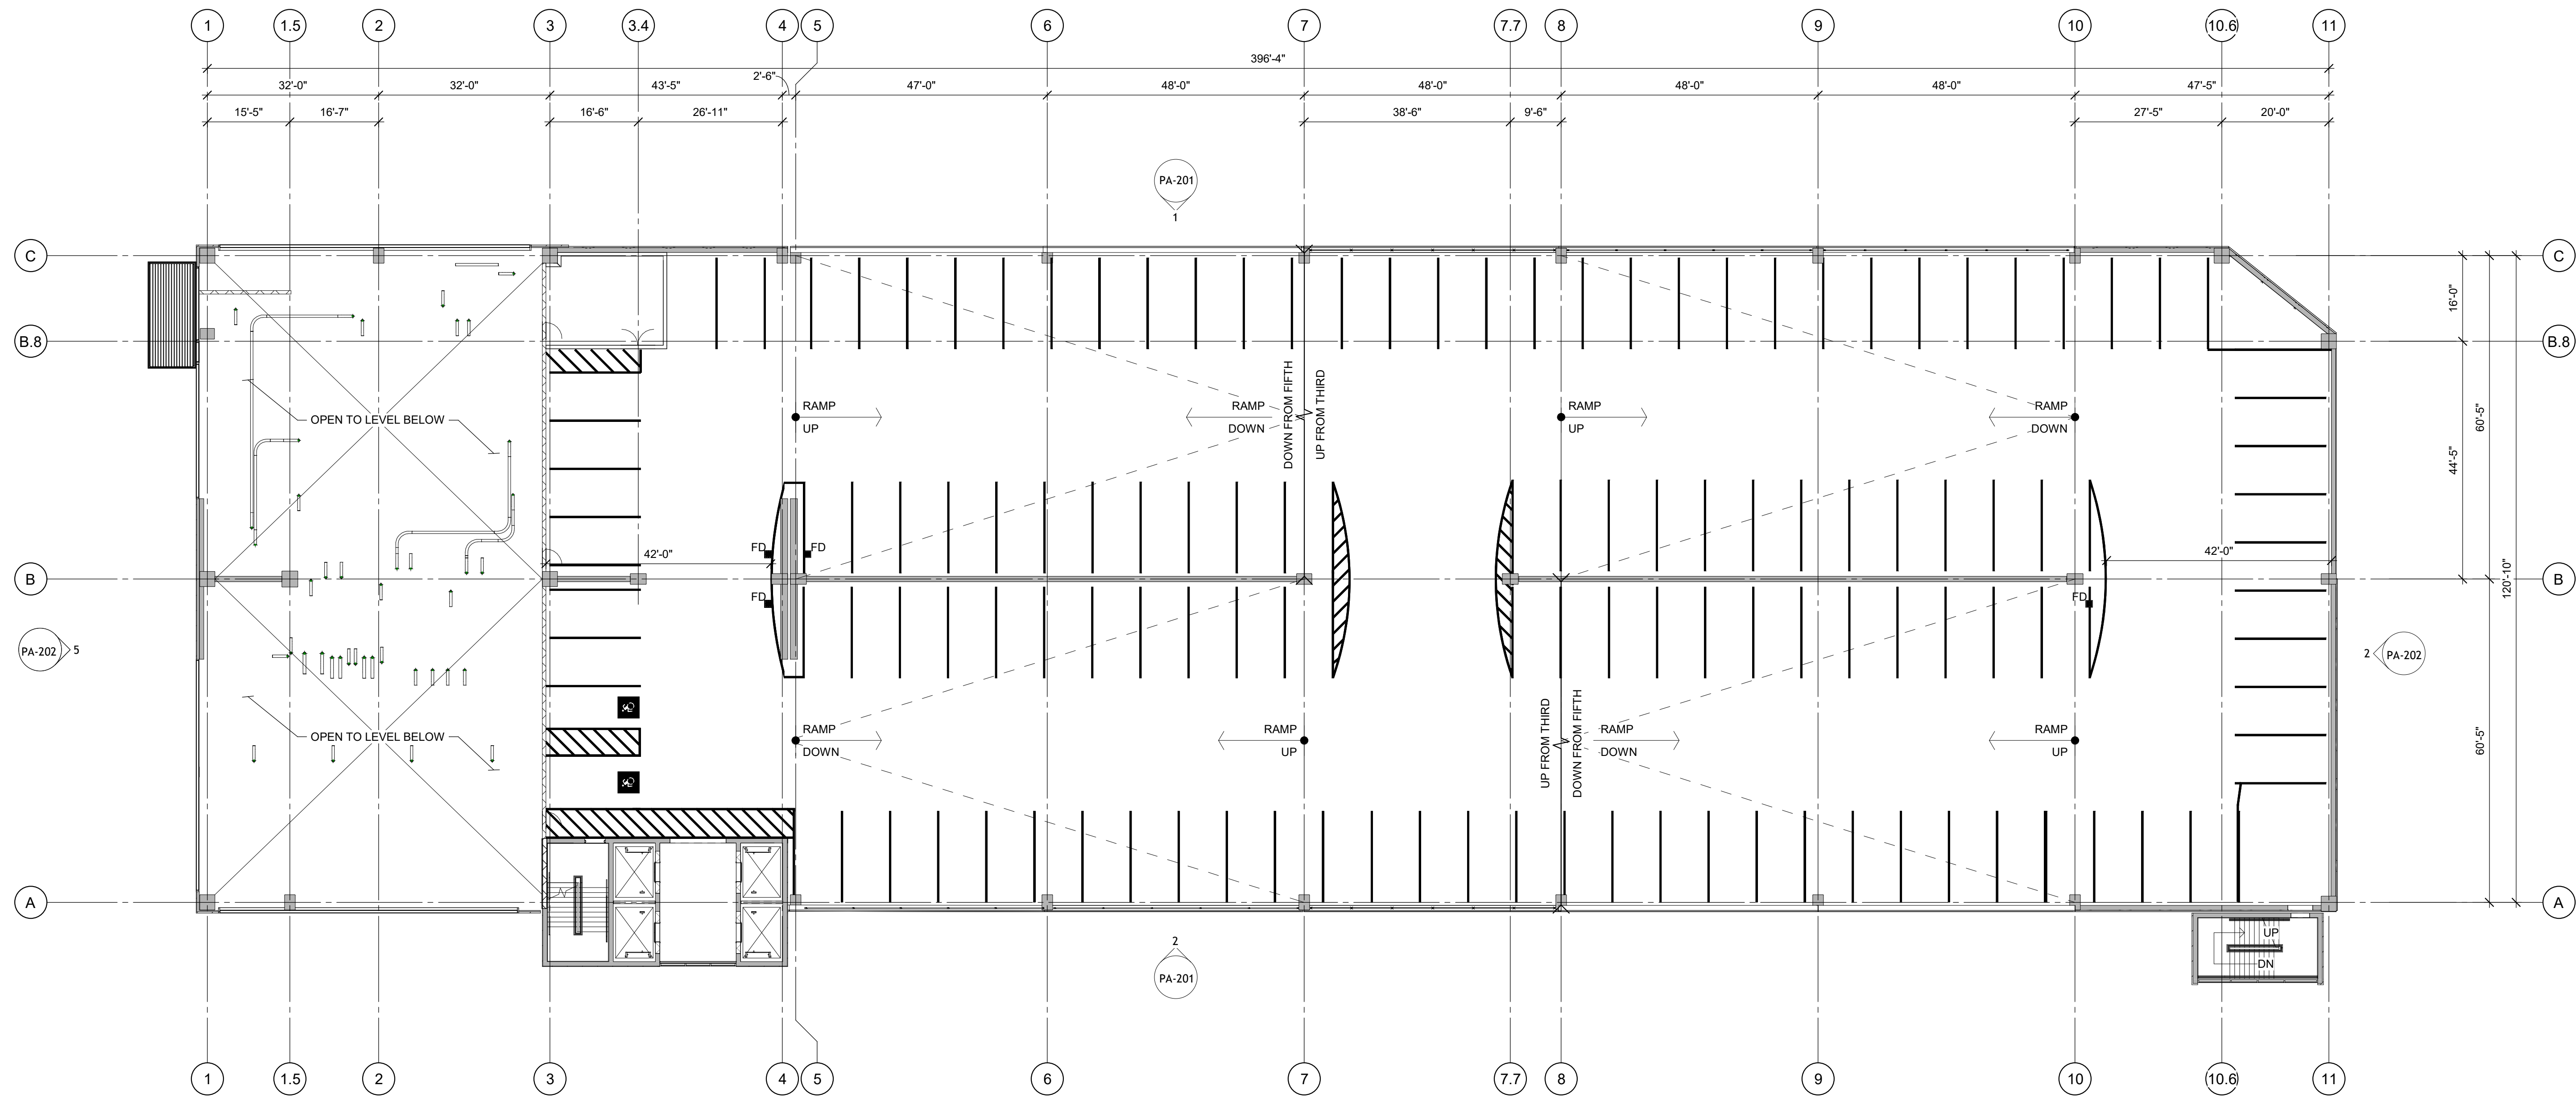

1 FOURTH TIER PLAN  
1/16" = 1'-0"

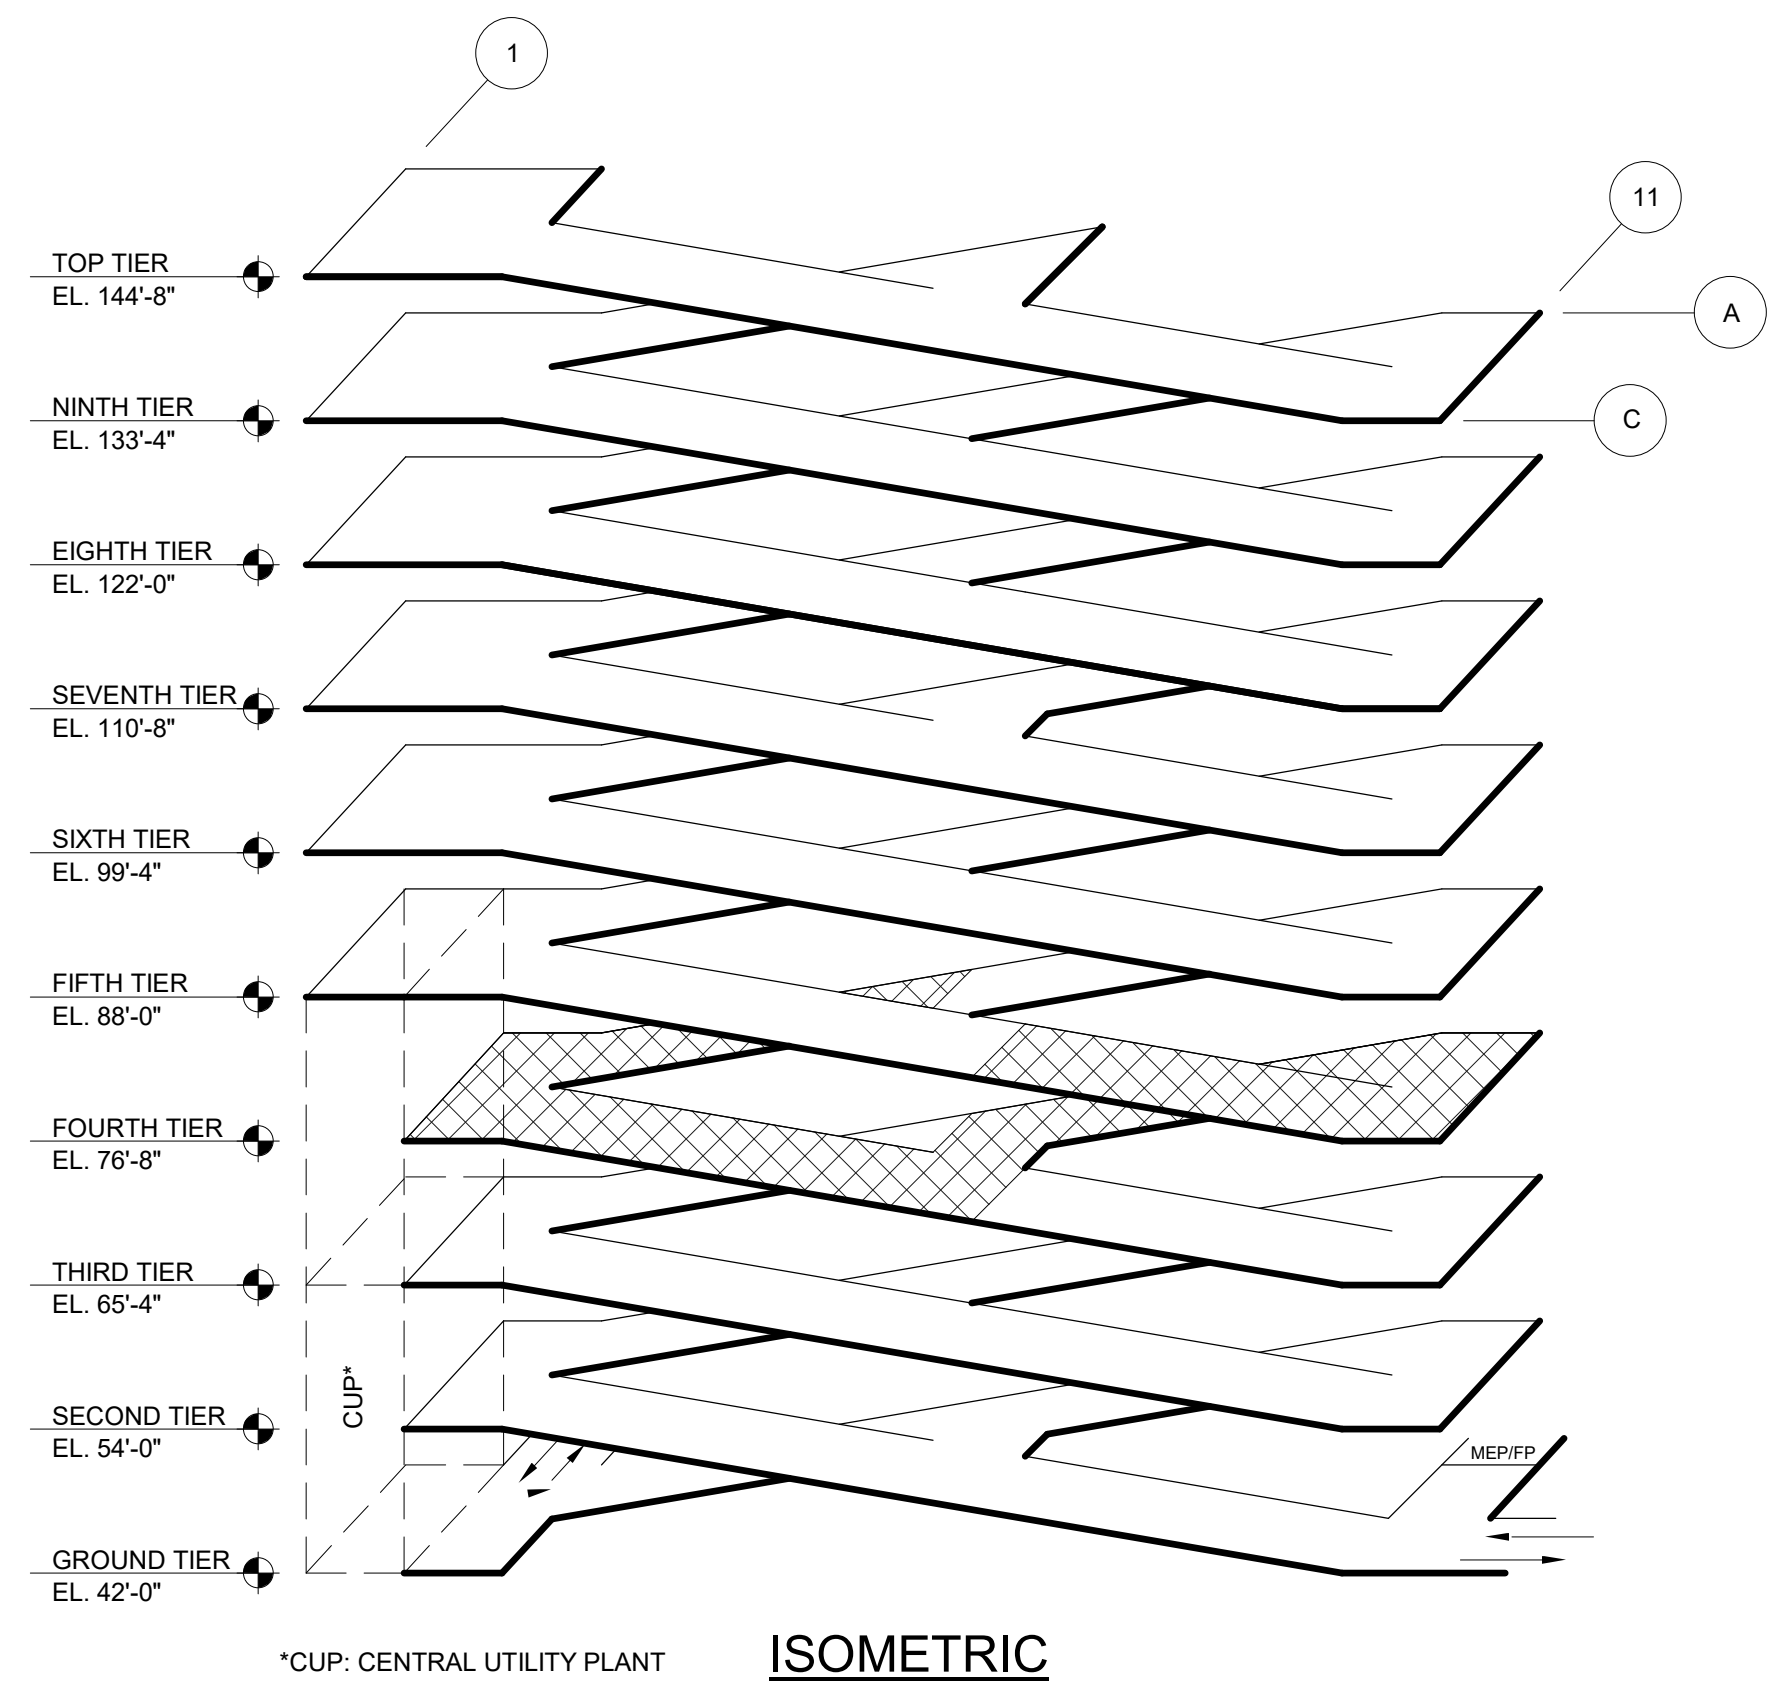

SHEET NOTES

1. SEE SHEET PA-100 FOR TYPICAL SHEET NOTES AND LOCATIONS OF TYPICAL DETAIL REFERENCES, UN.



49 West 38th St, 9th Floor  
New York, NY 10018  
212.286.2501 Ph  
www.walkerconsultants.com

SCOTT ASHLEY, PE  
EOR LICENSE NO: 24GE05535400

PRELIMINARY - DO NOT USE FOR CONSTRUCTION

LEGEND

- CIP
- CIP (PLAN CUT)
- PRECAST CONCRETE
- CMU
- CIP POUR STRIP
- TRAFFIC TOPPING
- PAVEMENT MARKING - NO PARKING AREA
- SHEET NOTE
- FIRE EXTINGUISHER CABINET
- PIPE BOLLARD
- SIGN LEGEND
- FLOOR DRAIN
- FLEXIBLE DELINEATOR POST
- EMERGENCY CALL STATION

JSUMC-Neptune Garage  
Jersey Shore University  
Medical Center  
81 DAVIS AVENUE  
TOWNSHIP OF NEPTUNE  
MONMOUTH COUNTY, NJ


| MARK      | DATE       | DESCRIPTION    |
|-----------|------------|----------------|
| REVISIONS |            |                |
| 1         | 02/06/2025 | PLANNING BOARD |

ISSUE DATE: 02/06/2025  
PROJECT NO: 18-002290.00  
DRAWN BY: C.LUIS  
CHECKED BY: L.GE


COPYRIGHT © 2024. ALL RIGHTS RESERVED. NO PART OF THIS DOCUMENT MAY BE REPRODUCED IN ANY FORM OR BY ANY MEANS WITHOUT PERMISSION FROM WALKER CONSULTANTS.

SHEET TITLE:  
FOURTH TIER PLAN

2/5/2025 3:01:06 PM Autodesk Docs://18-002290.00 JSUMC-Neptune Design-Build/2290\_NJ-Neptune\_Garage\_Struct\_R04.rvt

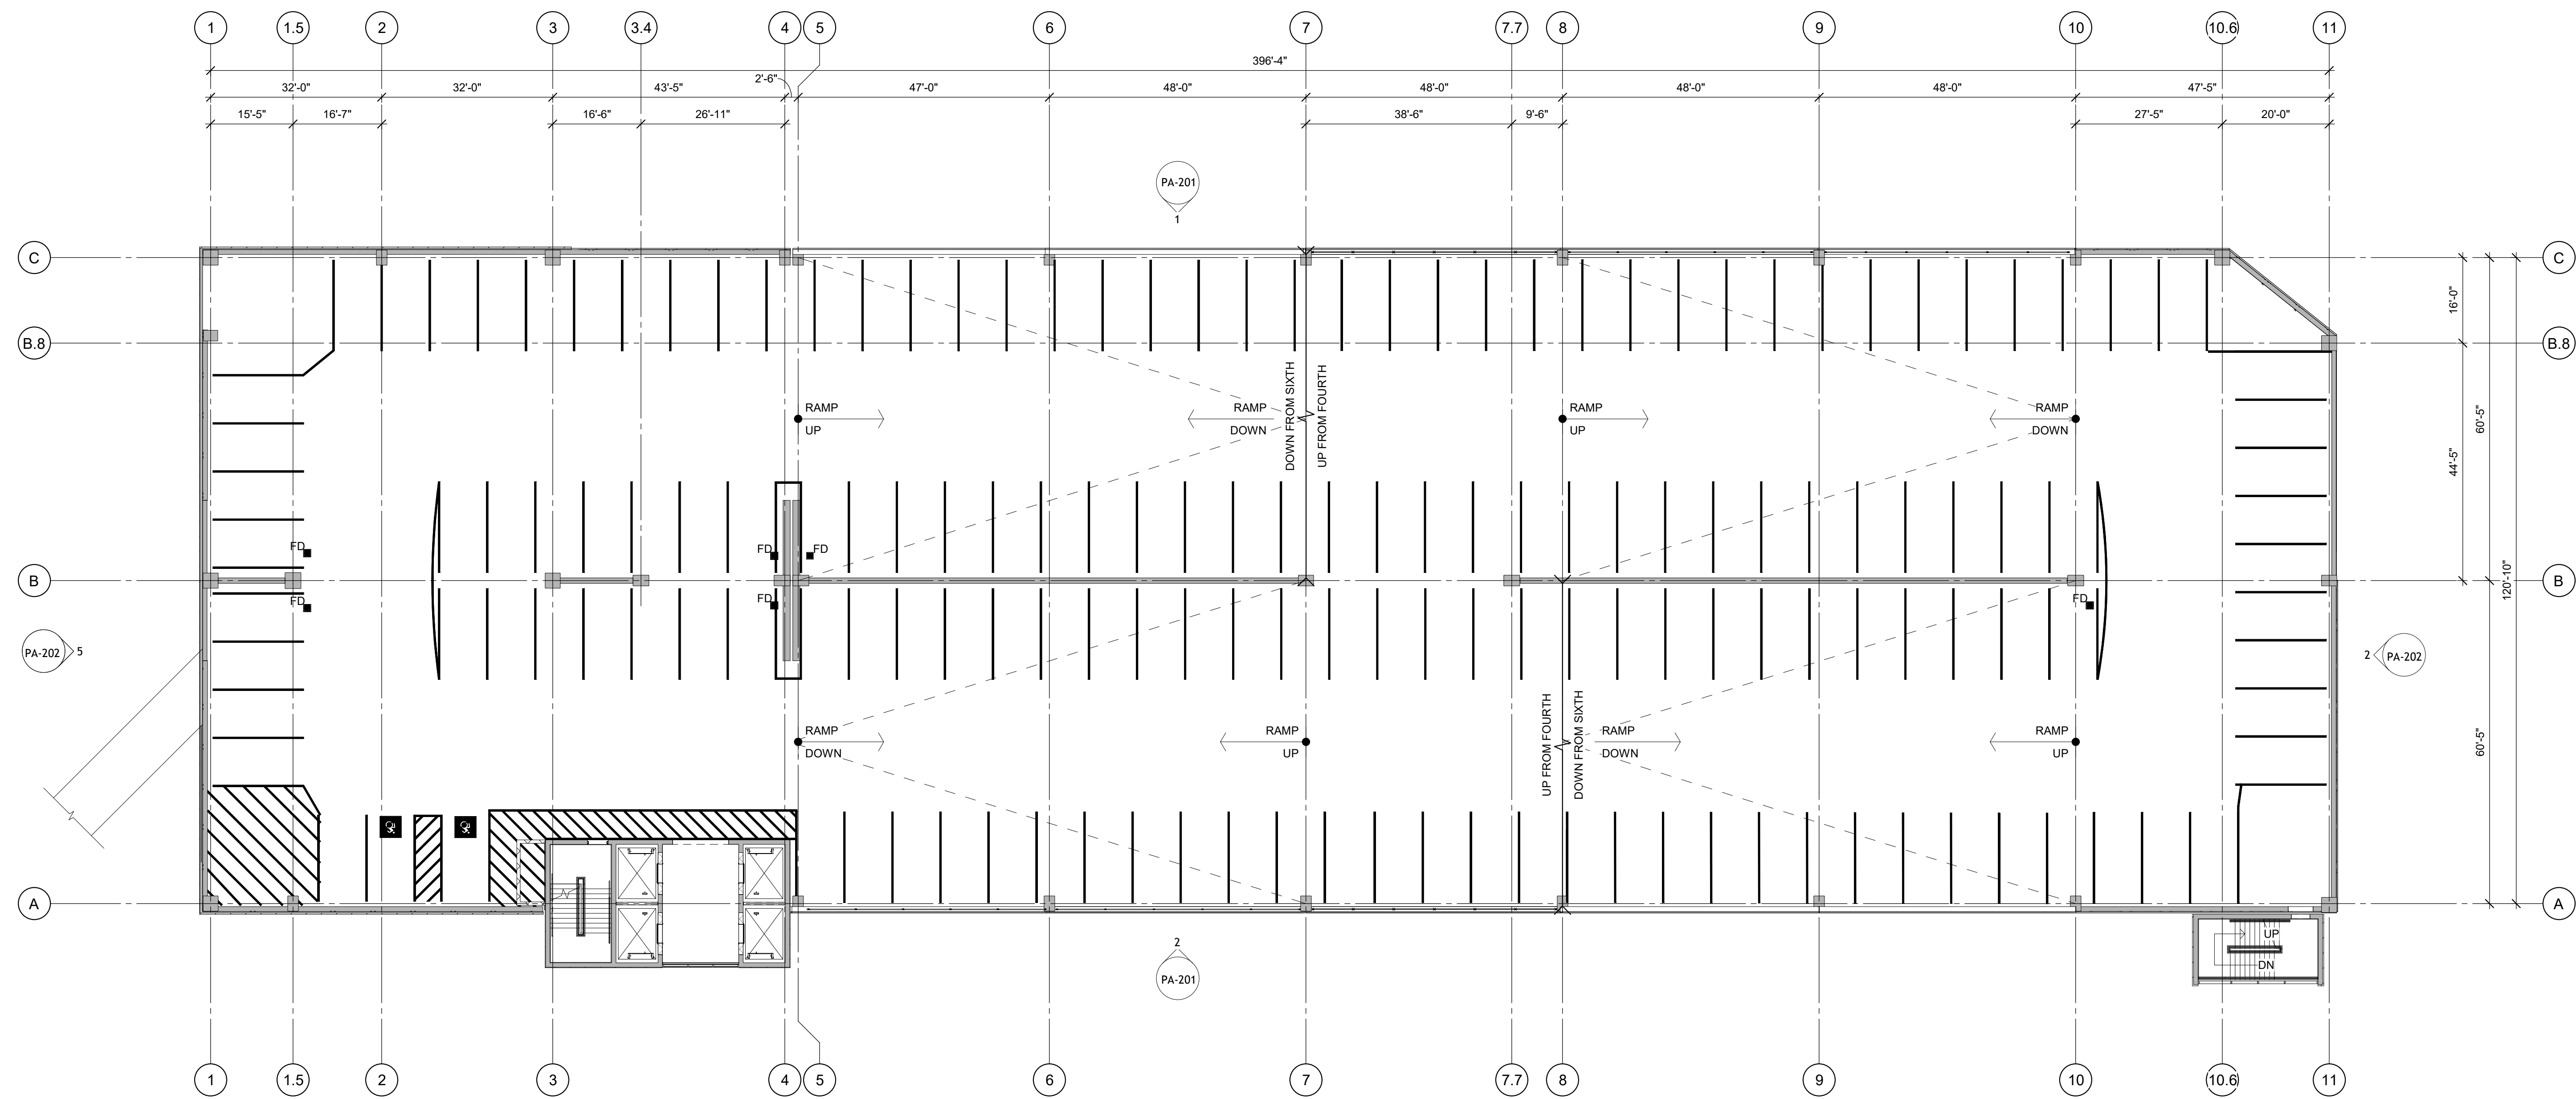

1 FIFTH TIER PLAN  
1/16" = 1'-0"

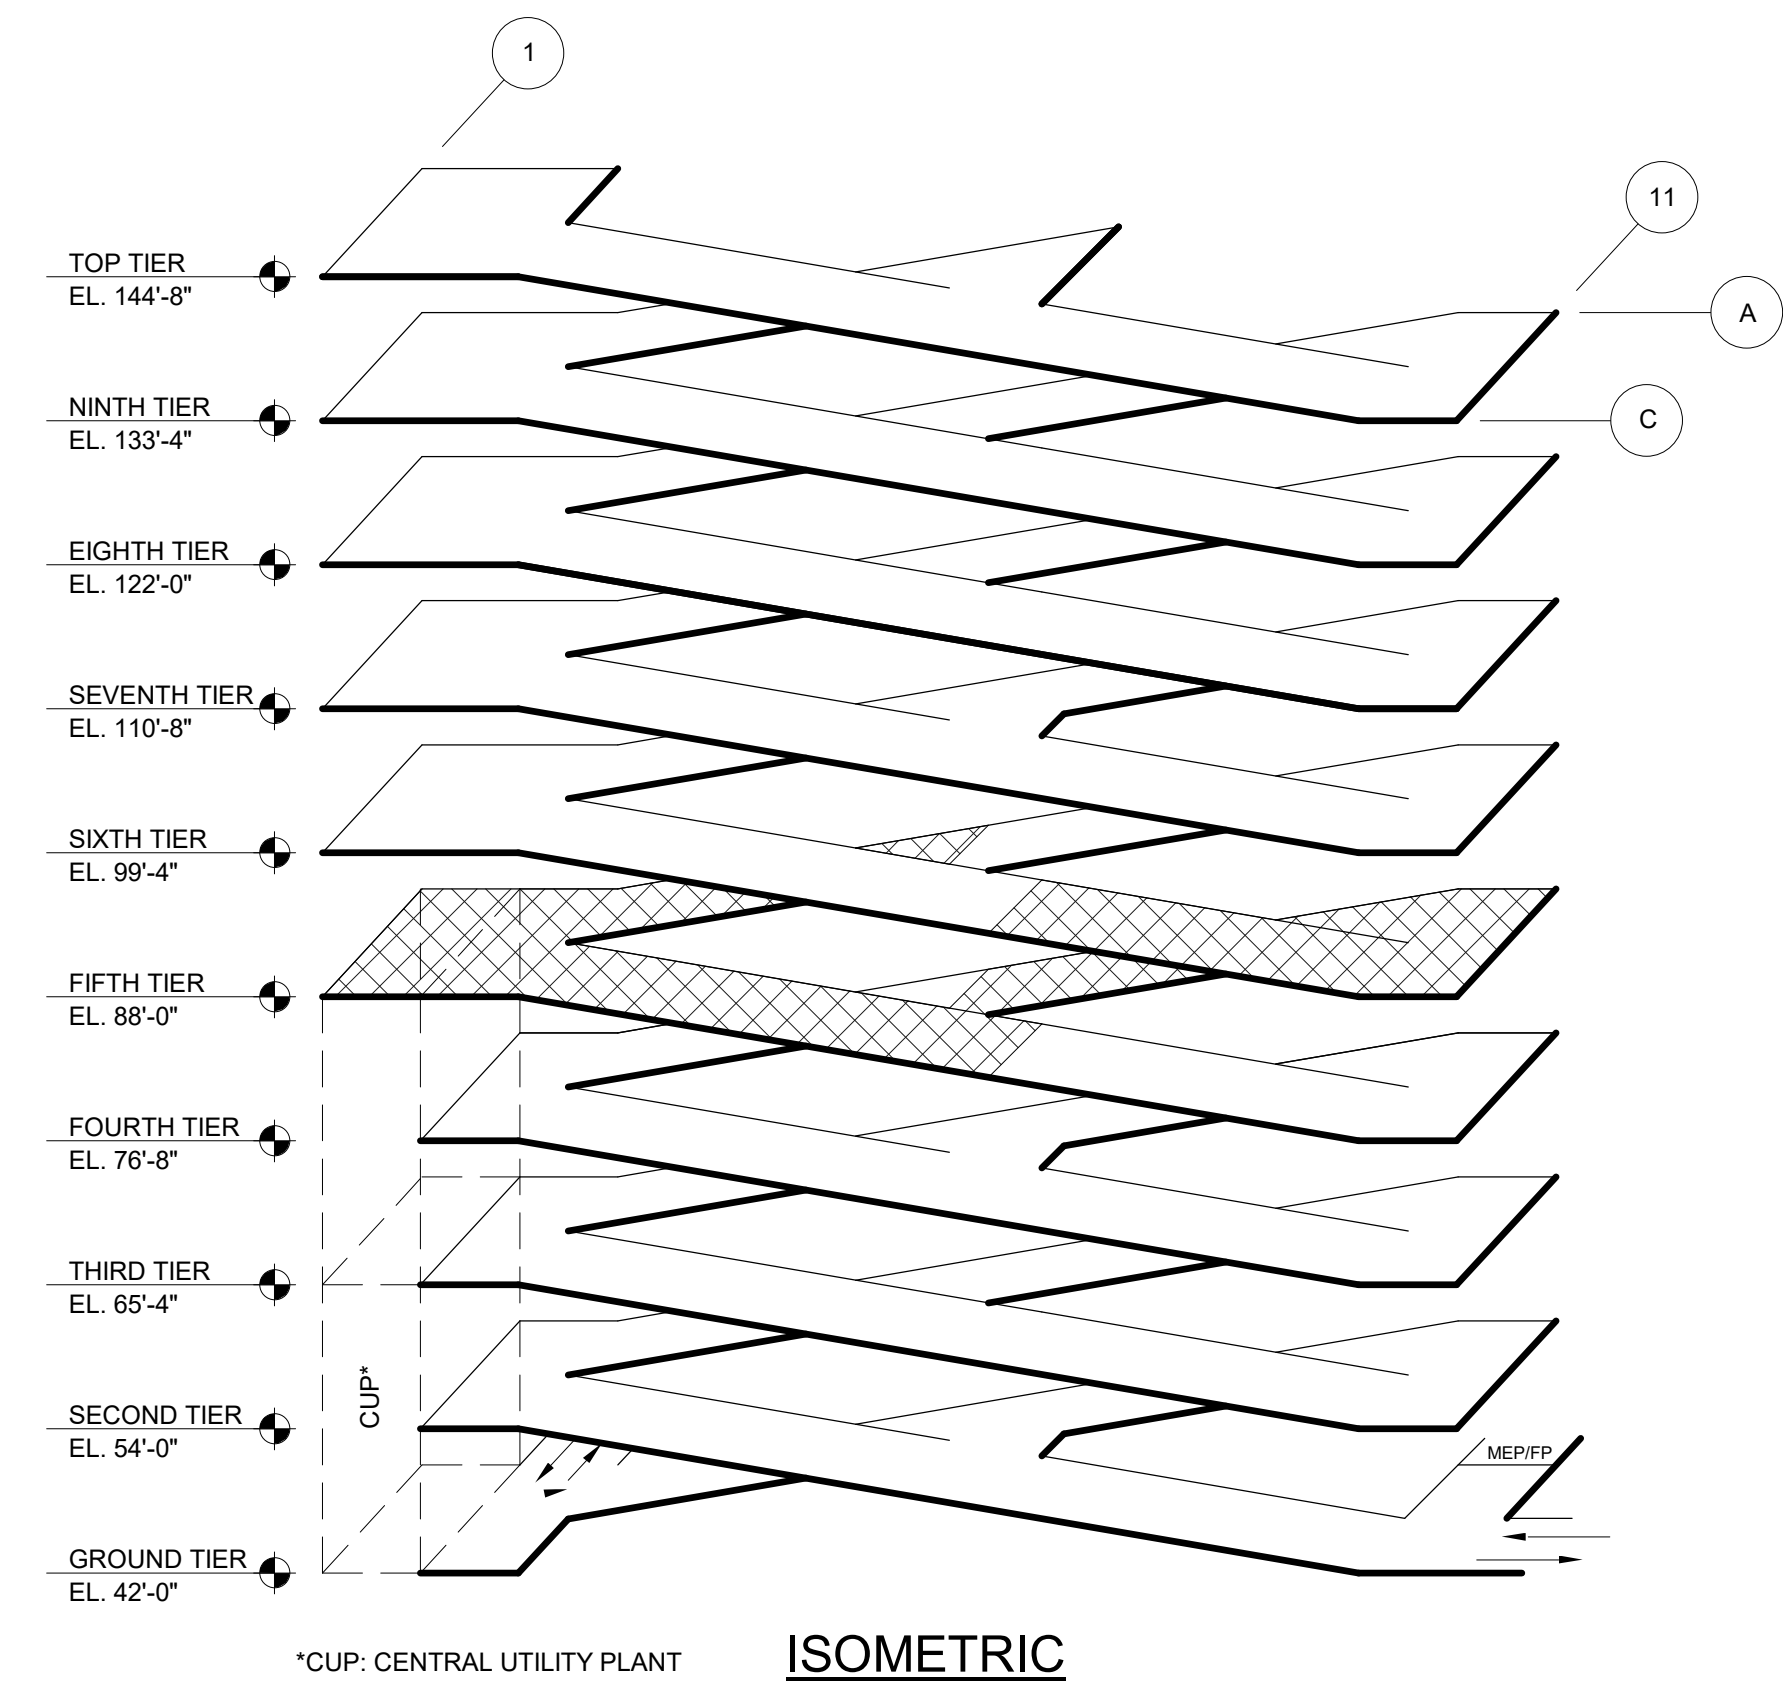

## SHEET NOTES

1. SEE SHEET PA-100 FOR TYPICAL SHEET NOTES AND LOCATIONS OF TYPICAL DETAIL REFERENCES, UN.



49 West 38th St, 9th Floor  
New York, NY 10018  
212.286.2501 Ph  
www.walkerconsultants.com

SCOTT ASHLEY, PE  
EOR LICENSE NO: 24GE05535400

PRELIMINARY - DO NOT USE FOR CONSTRUCTION

## LEGEND

- CIP
- CIP (PLAN CUT)
- PRECAST CONCRETE
- CMU
- CIP POUR STRIP
- TRAFFIC TOPPING
- PAVEMENT MARKING - NO PARKING AREA
- SHEET NOTE
- FIRE EXTINGUISHER CABINET
- PIPE BOLLARD
- SIGN LEGEND
- FLOOR DRAIN
- FLEXIBLE DELINEATOR POST
- EMERGENCY CALL STATION

JSUMC-Neptune Garage  
Jersey Shore University  
Medical Center  
81 DAVIS AVENUE  
TOWNSHIP OF NEPTUNE  
MONMOUTH COUNTY, NJ


| MARK | DATE         | DESCRIPTION    |
|------|--------------|----------------|
| 1    | 02/06/2025   | PLANNING BOARD |
| 2    | 02/06/2025   | ISSUE DATE     |
| 3    | 18-002290.00 | PROJECT NO.    |
| 4    | C.LUIS       | DRAWN BY       |
| 5    | L.GE         | CHECKED BY     |

COPYRIGHT © 2024. ALL RIGHTS RESERVED. NO PART OF THIS DOCUMENT MAY BE REPRODUCED IN ANY FORM OR BY ANY MEANS WITHOUT PERMISSION FROM WALKER CONSULTANTS.


SHEET TITLE:  
FIFTH TIER PLAN

PA-105

2/5/2025 3:01:07 PM Autodesk Docs://16-022290.00 JSUMC-Neptune Design-Build/2290\_NJ\_Neptune\_Garage\_Strud\_R04.rvt

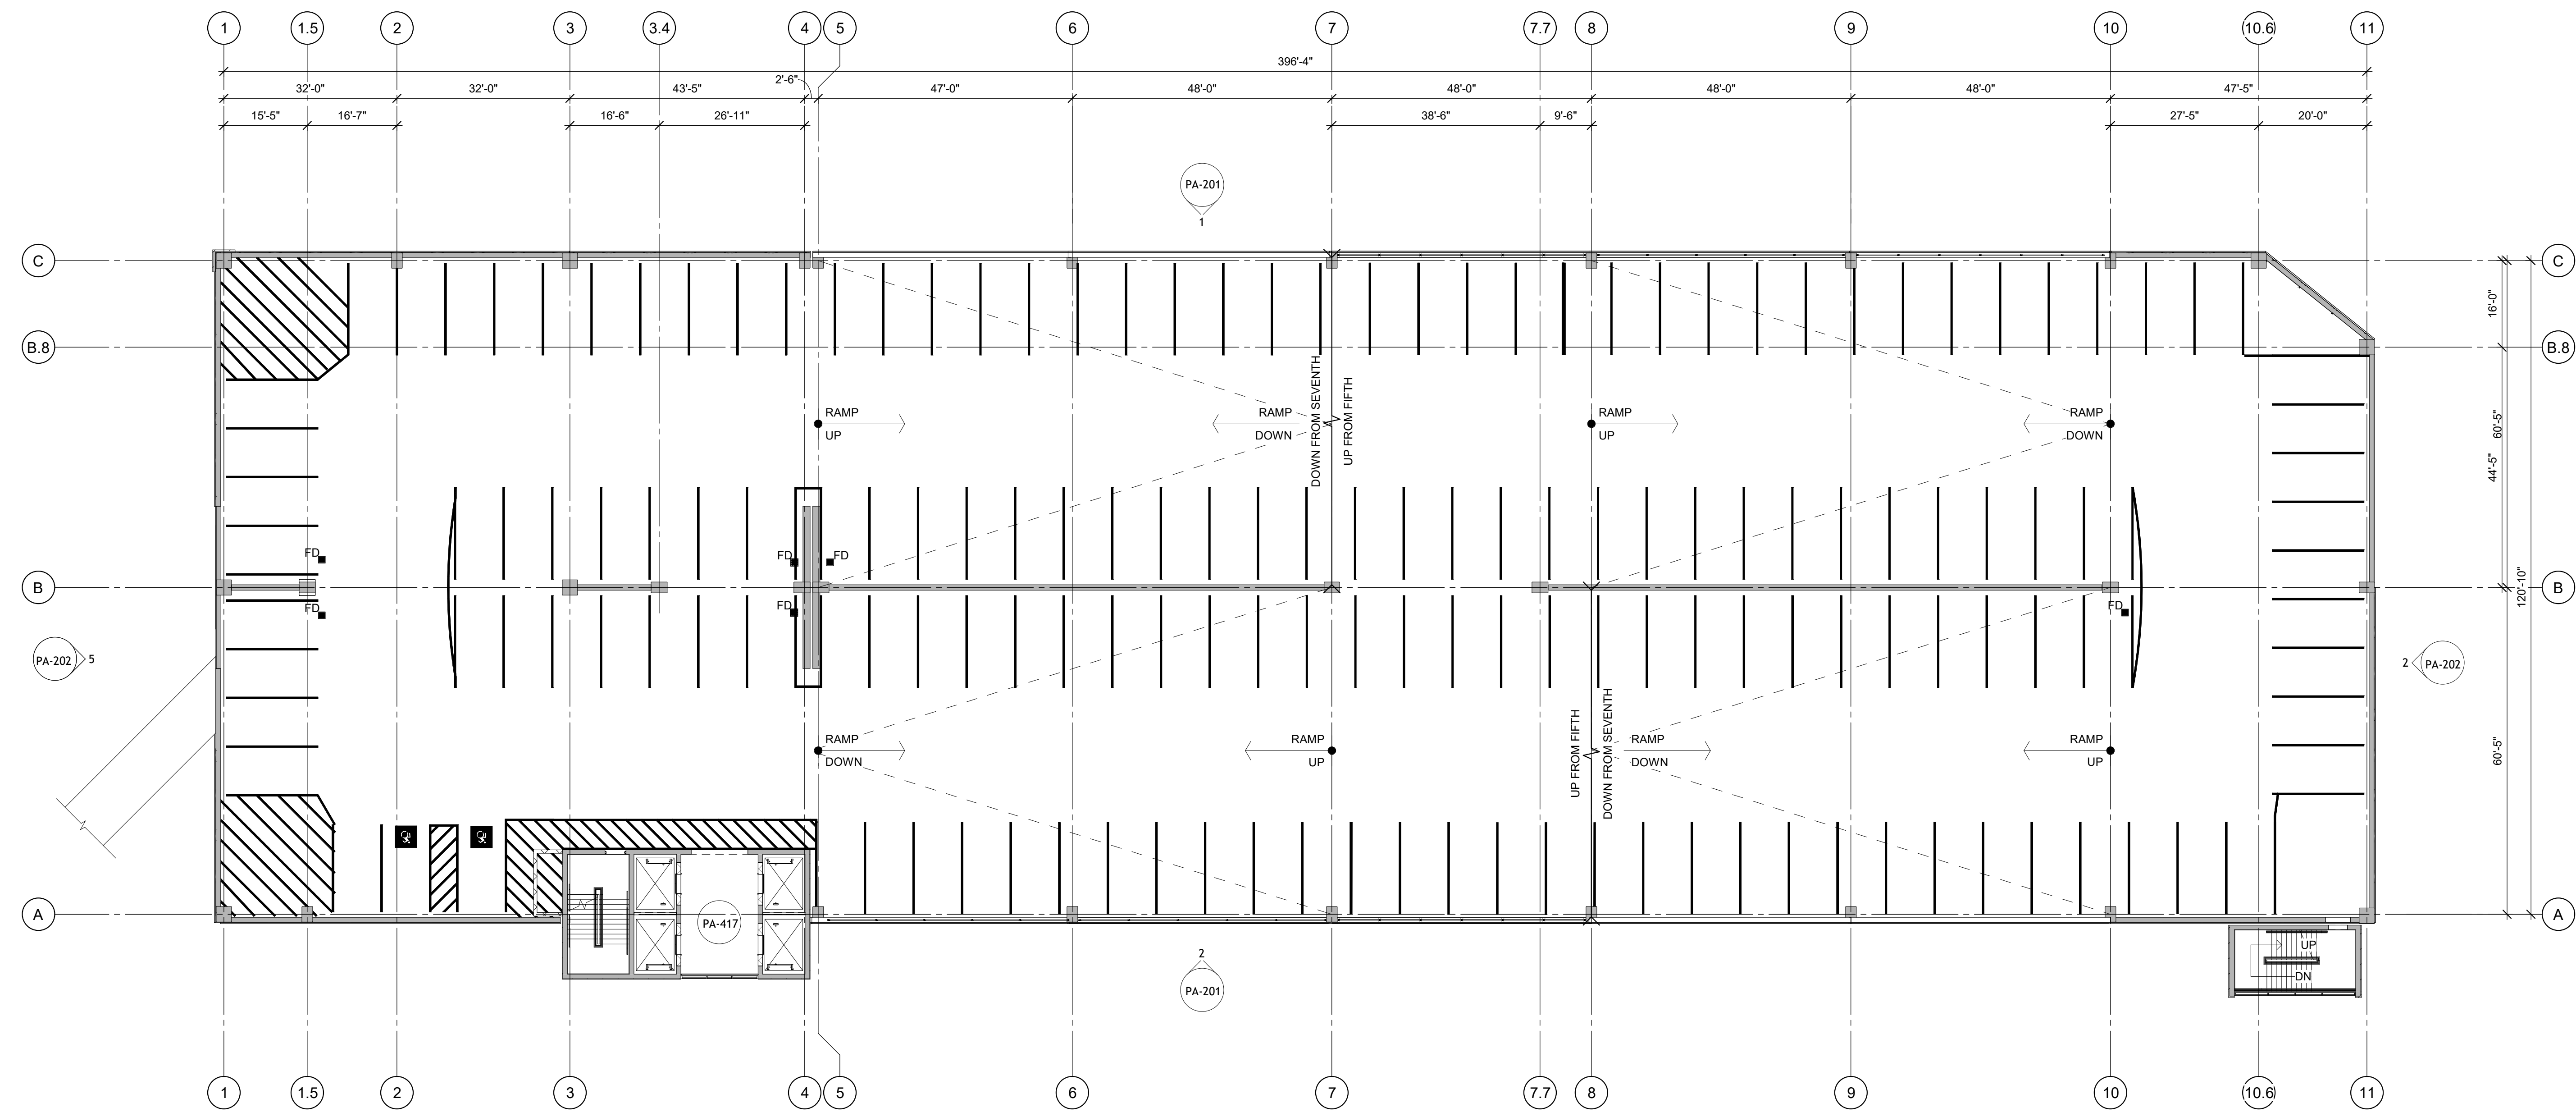

**SIXTH, EIGHTH, & NINTH TIER, TYPICAL PLAN**  
1  
1/16" = 1'-0"

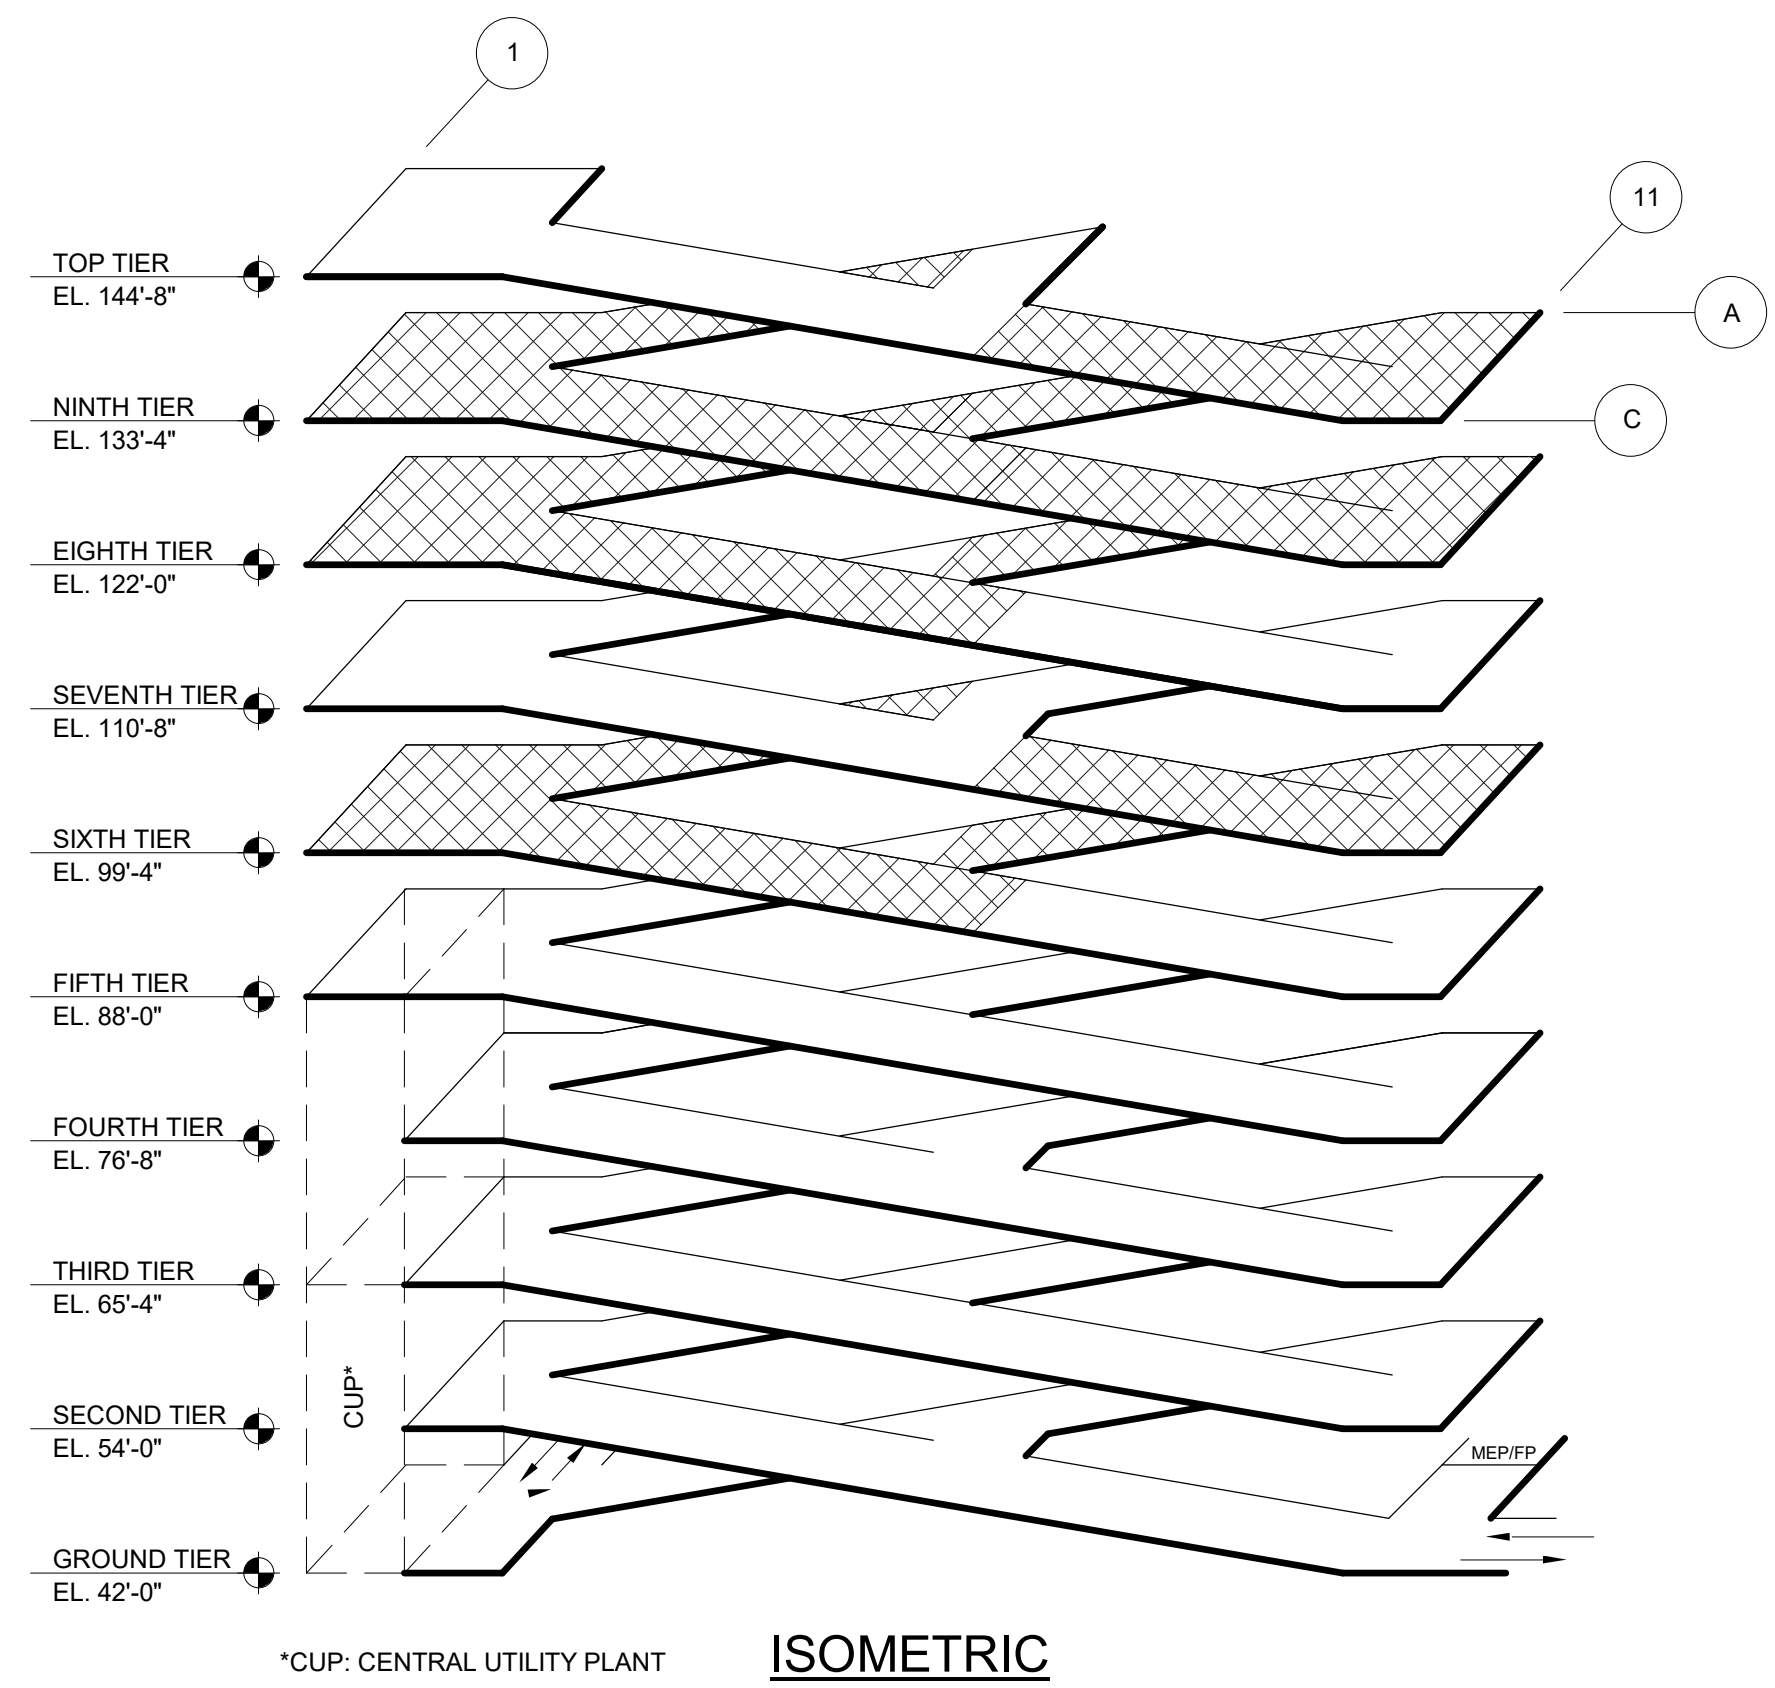

**SHEET NOTES**

1. SEE SHEET PA-100 FOR TYPICAL SHEET NOTES AND LOCATIONS OF TYPICAL DETAIL REFERENCES, UN.



49 West 38th St, 9th Floor  
New York, NY 10018  
212.286.2501 Ph  
www.walkerconsultants.com

SCOTT ASHLEY, PE  
EOR LICENSE NO: 24GE05535400

PRELIMINARY - DO NOT USE FOR CONSTRUCTION

**LEGEND**

- CIP
- CIP (PLAN CUT)
- PRECAST CONCRETE
- CMU
- CIP POUR STRIP
- TRAFFIC TOPPING
- PAVEMENT MARKING - NO PARKING AREA
- SHEET NOTE
- FIRE EXTINGUISHER CABINET
- PIPE BOLLARD
- SIGN LEGEND
- FLOOR DRAIN
- FLEXIBLE DELINEATOR POST
- EMERGENCY CALL STATION


JSUMC-Neptune Garage  
Jersey Shore University  
Medical Center  
81 DAVIS AVENUE  
TOWNSHIP OF NEPTUNE  
MONMOUTH COUNTY, NJ

| MARK | DATE         | DESCRIPTION    |
|------|--------------|----------------|
| 1    | 02/06/2025   | PLANNING BOARD |
| 2    | 02/06/2025   | ISSUE DATE     |
| 3    | 16-022290.00 | PROJECT NO.    |
| 4    | C.LUIS       | DRAWN BY       |
| 5    | L.GE         | CHECKED BY     |


COPYRIGHT © 2024. ALL RIGHTS RESERVED. NO PART OF THIS DOCUMENT MAY BE REPRODUCED IN ANY FORM OR BY ANY MEANS WITHOUT PERMISSION FROM WALKER CONSULTANTS.

SHEET TITLE  
**SIXTH TIER PLAN**

2/5/2025 3:01:08 PM Autodesk Docs://18-002290.00 JSUMC-Neptune Design-Build/2290\_NJ\_Neptune\_Garage\_Struct\_R04.rvt

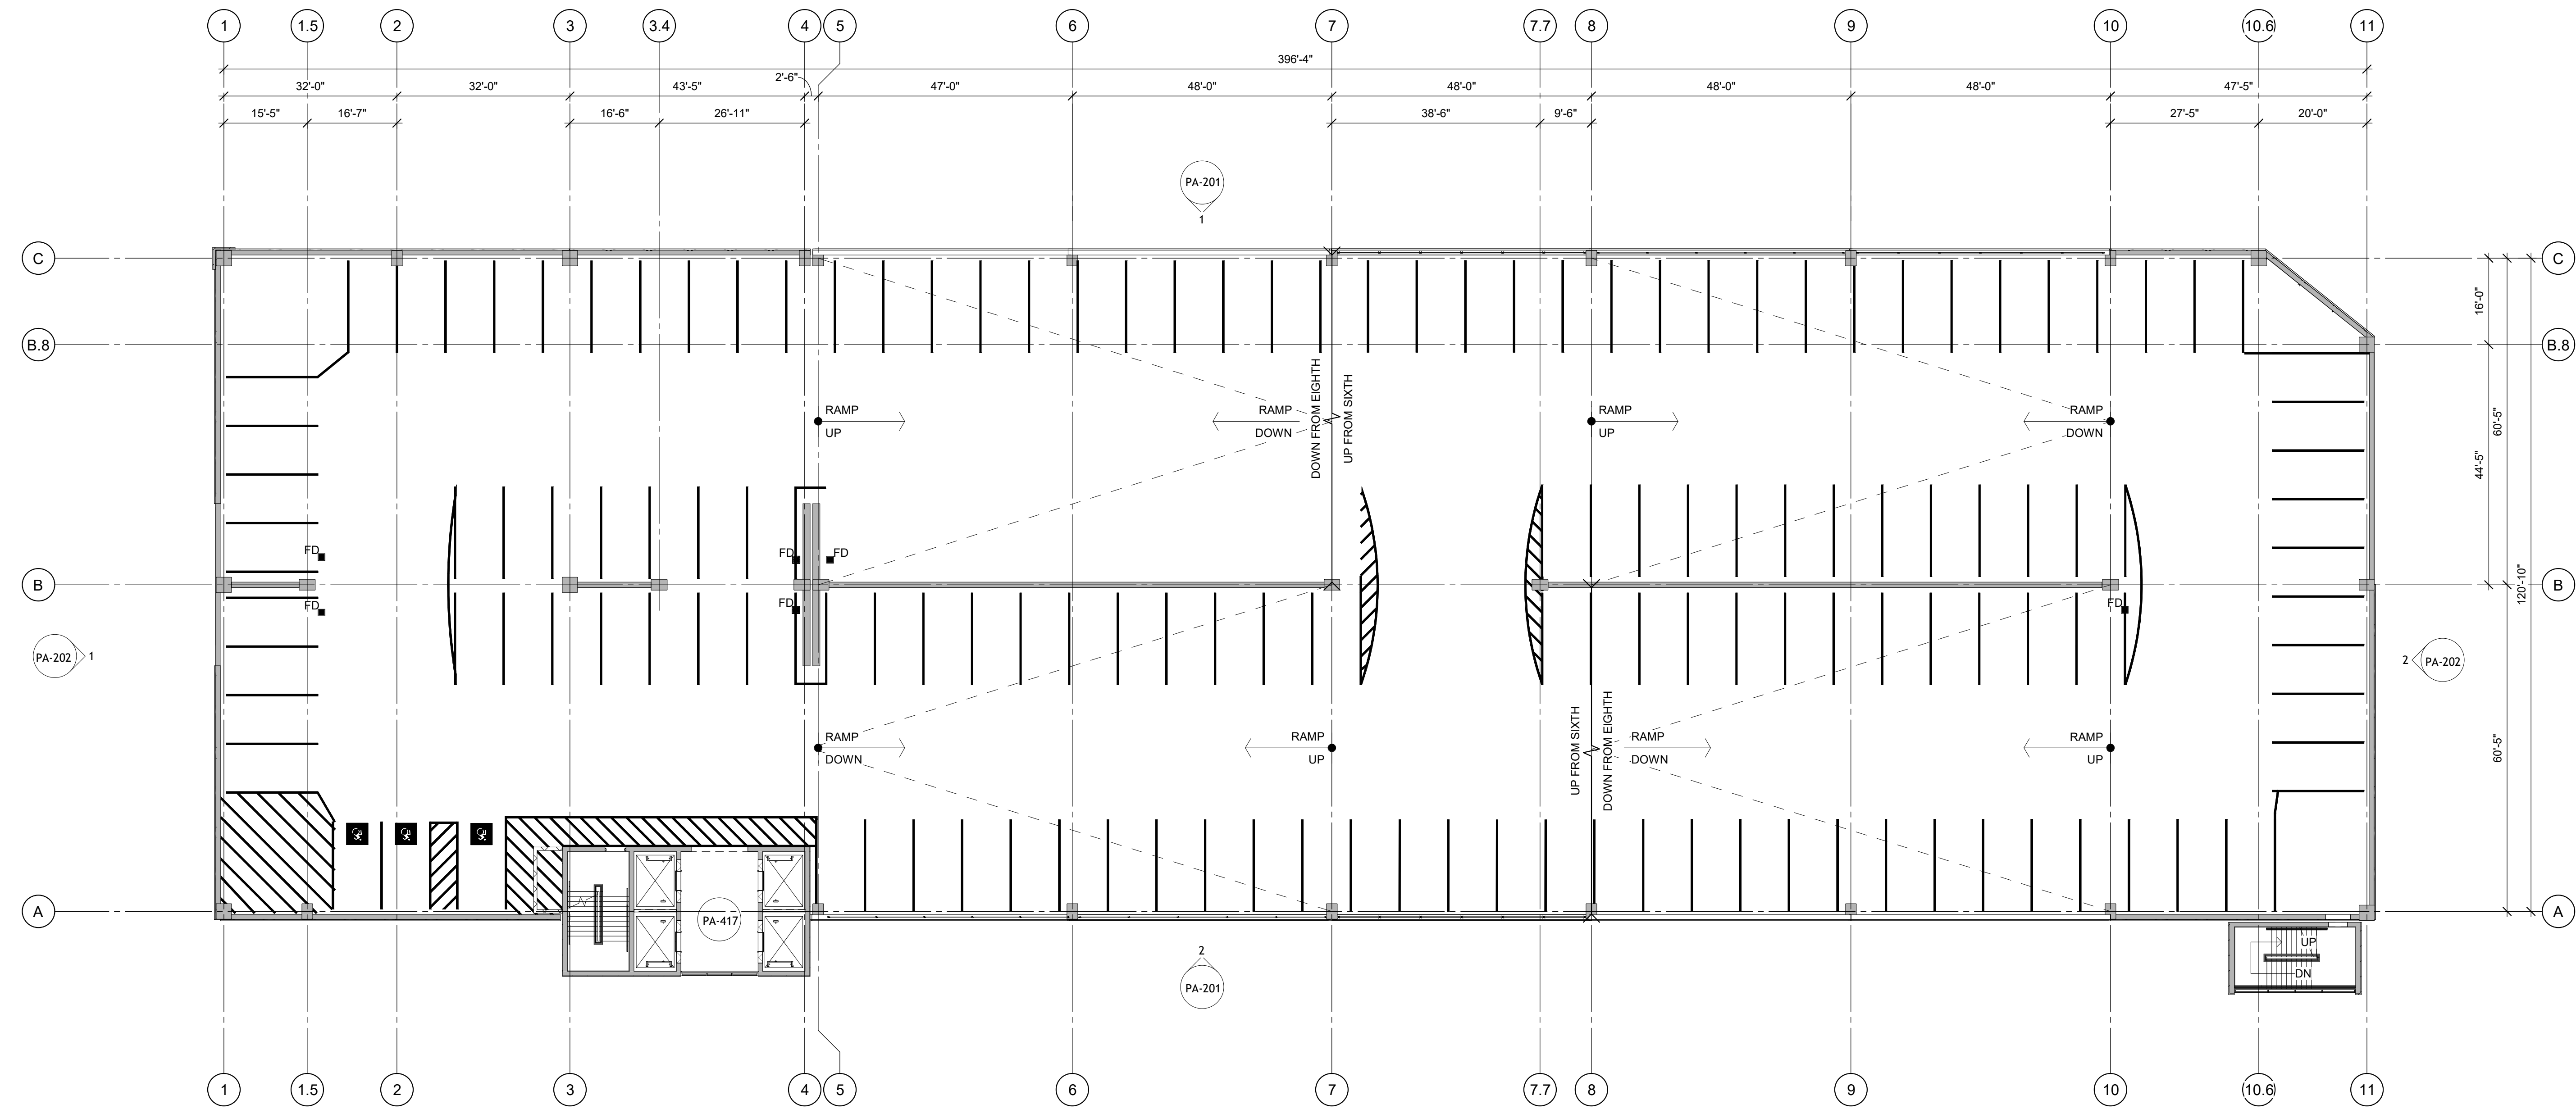

1 SEVENTH TIER PLAN  
1/16" = 1'-0"

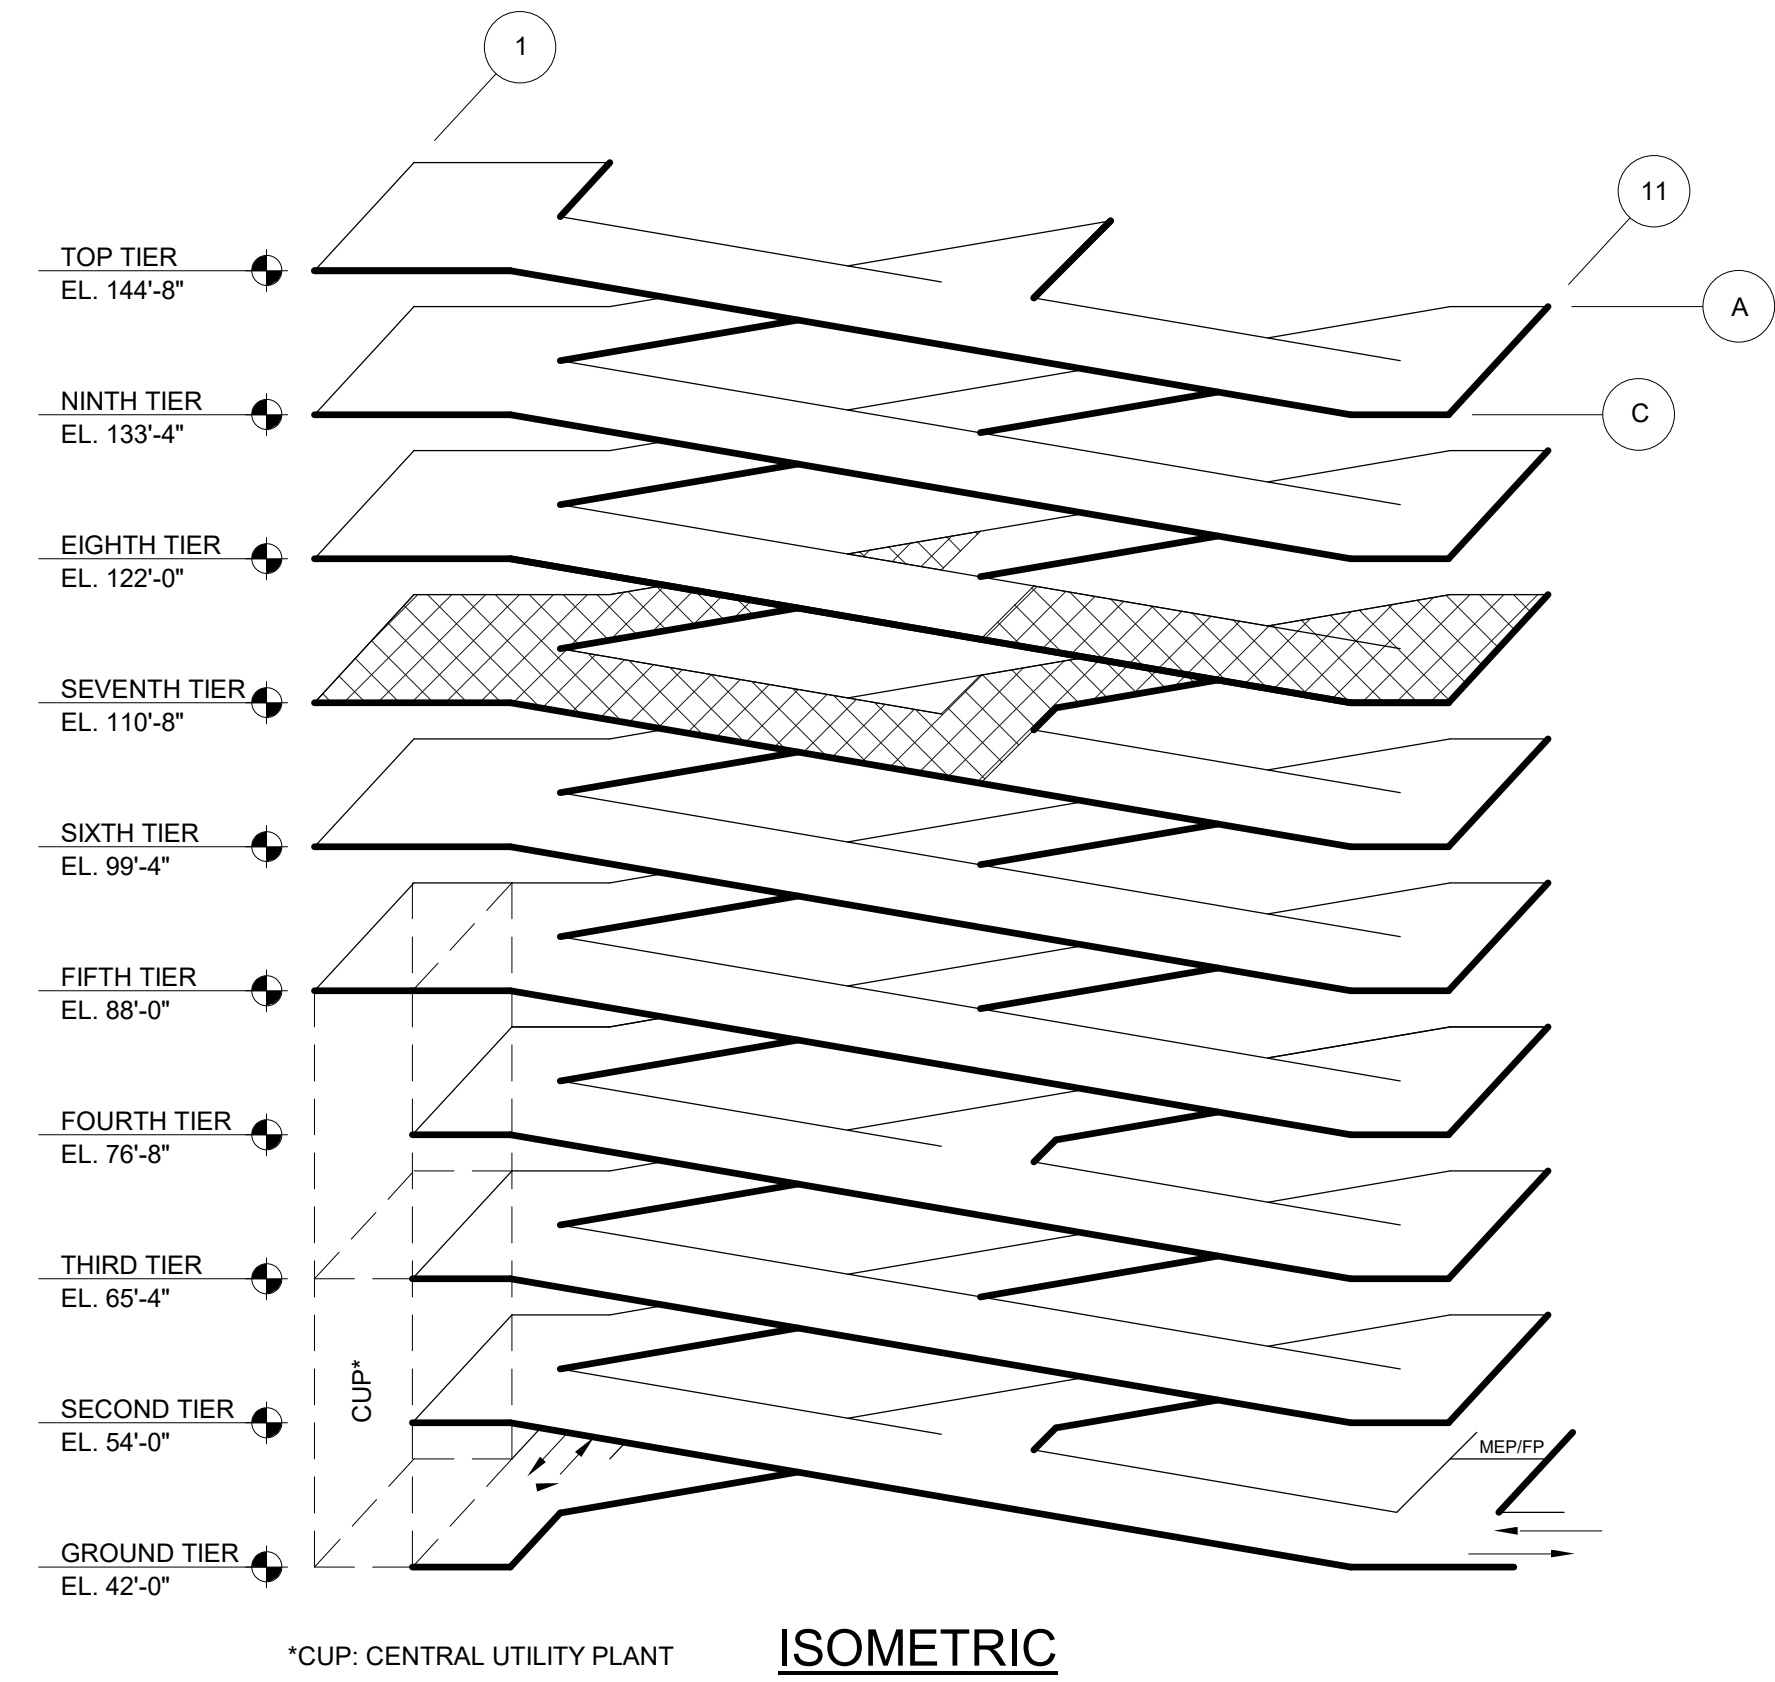

SHEET NOTES

1. SEE SHEET PA-100 FOR TYPICAL SHEET NOTES AND LOCATIONS OF TYPICAL DETAIL REFERENCES, UN.



49 West 38th St, 9th Floor  
New York, NY 10018  
212.286.2501 Ph  
www.walkerconsultants.com

SCOTT ASHLEY, PE  
EOR LICENSE NO: 24GE05535400

PRELIMINARY - DO NOT USE FOR CONSTRUCTION

LEGEND

- CIP
- CIP (PLAN CUT)
- PRECAST CONCRETE
- CMU
- CIP POUR STRIP
- TRAFFIC TOPPING
- PAVEMENT MARKING - NO PARKING AREA
- SHEET NOTE
- FIRE EXTINGUISHER CABINET
- PIPE BOLLARD
- SIGN LEGEND
- FLOOR DRAIN
- FLEXIBLE DELINEATOR POST
- EMERGENCY CALL STATION


JSUMC-Neptune Garage  
Jersey Shore University  
Medical Center  
81 DAVIS AVENUE  
TOWNSHIP OF NEPTUNE  
MONMOUTH COUNTY, NJ

| MARK | DATE       | DESCRIPTION              |
|------|------------|--------------------------|
| 1    | 02/06/2025 | PLANNING BOARD           |
| 2    | 02/06/2025 | ISSUE DATE               |
| 3    | 02/06/2025 | PROJECT NO: 18-002290.00 |
| 4    | 02/06/2025 | DRAWN BY: C.LUIS         |
| 5    | 02/06/2025 | CHECKED BY: L.GE         |


COPYRIGHT © 2024. ALL RIGHTS RESERVED. NO PART OF THIS DOCUMENT MAY BE REPRODUCED IN ANY FORM OR BY ANY MEANS WITHOUT PERMISSION FROM WALKER CONSULTANTS.

SHEET TITLE:  
SEVENTH TIER PLAN


2/5/2025 3:01:20 PM Autodesk Docs://18-002290.00 JSUMC-Neptune Design-Build/2290\_NJ\_Neptune\_Garage\_Strud\_R04.rvt

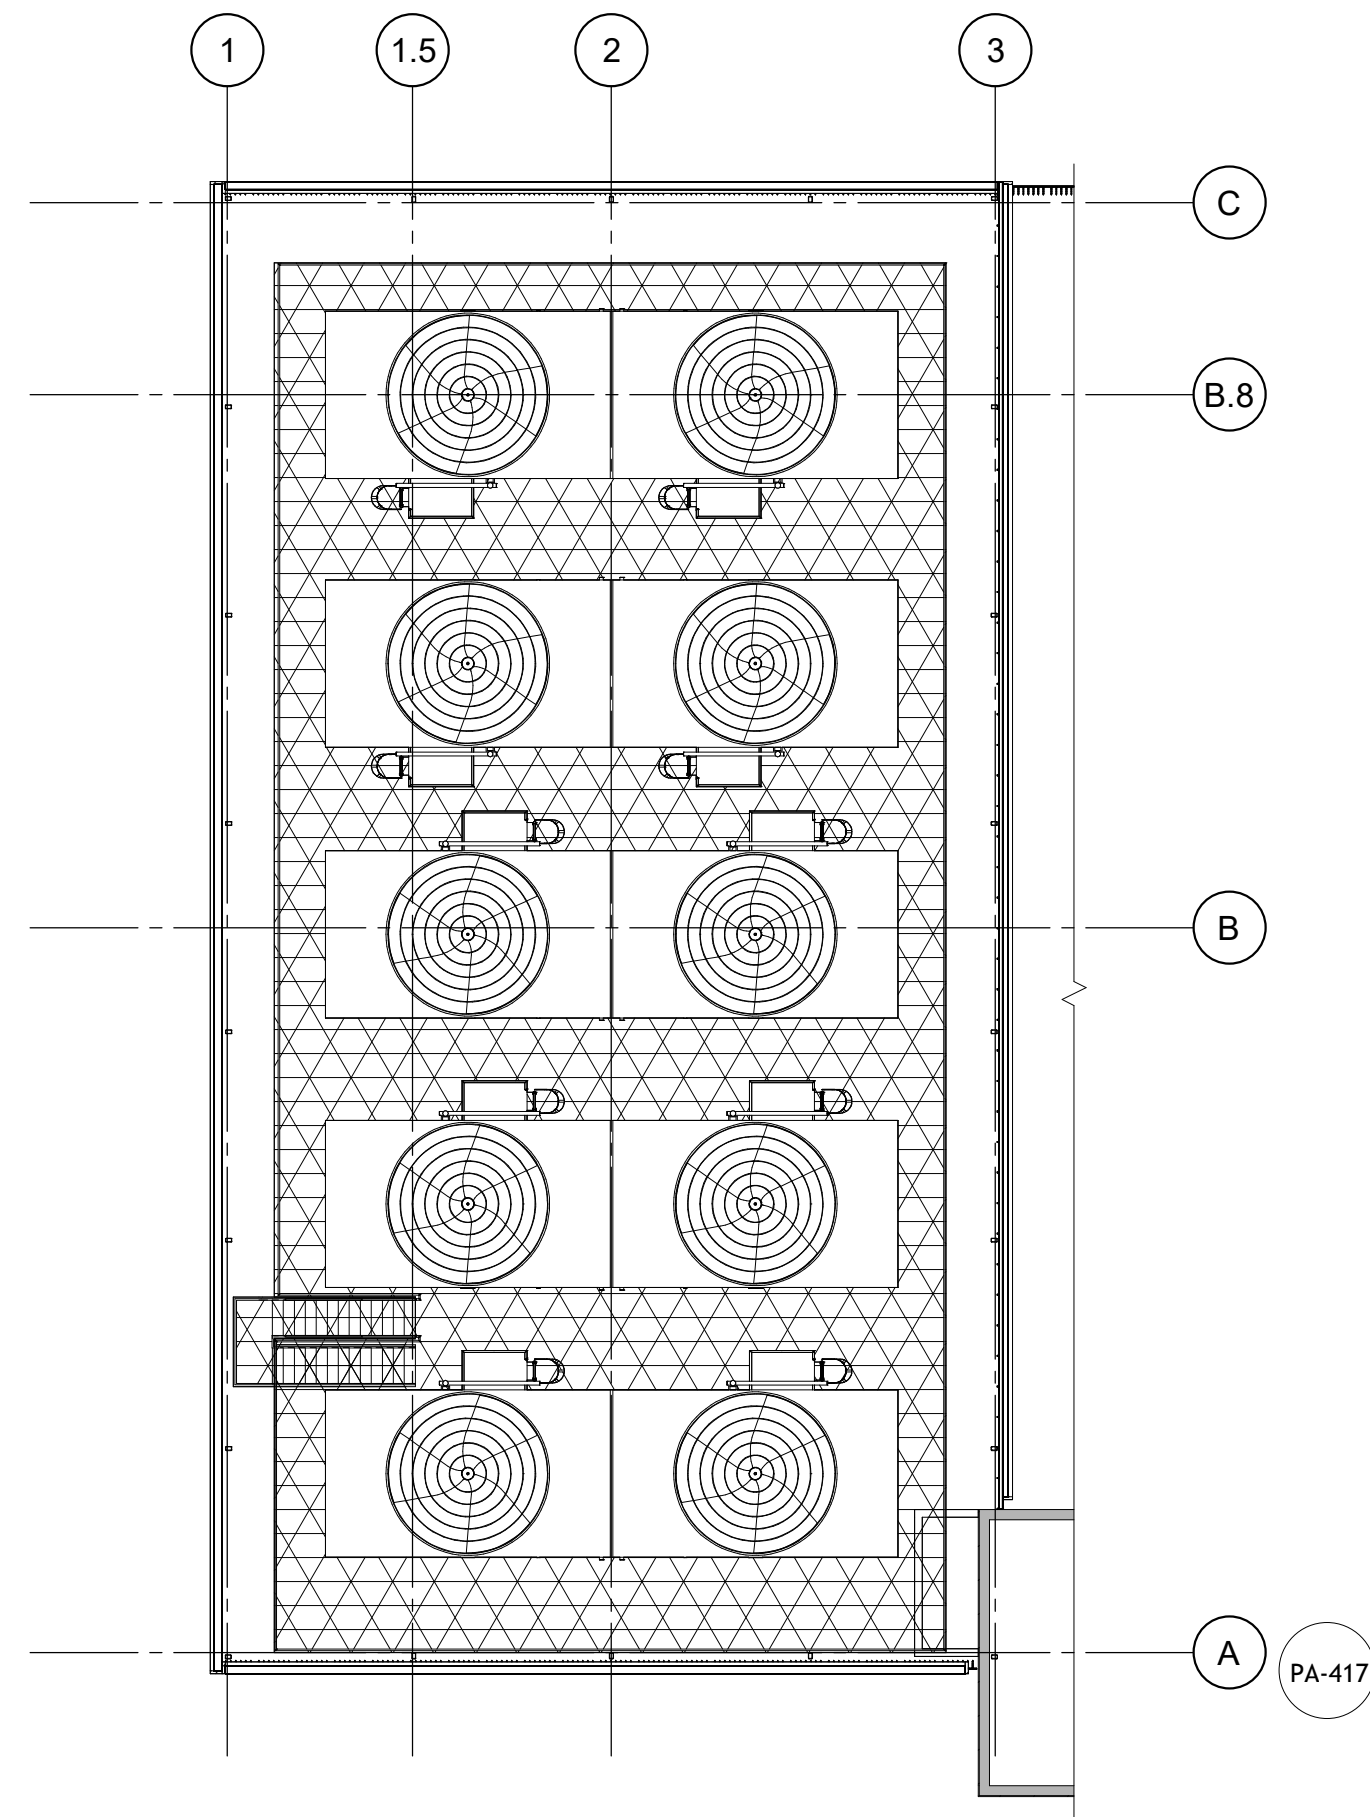

2 COOLING TOWER PLAN  
1/16" = 1'-0"

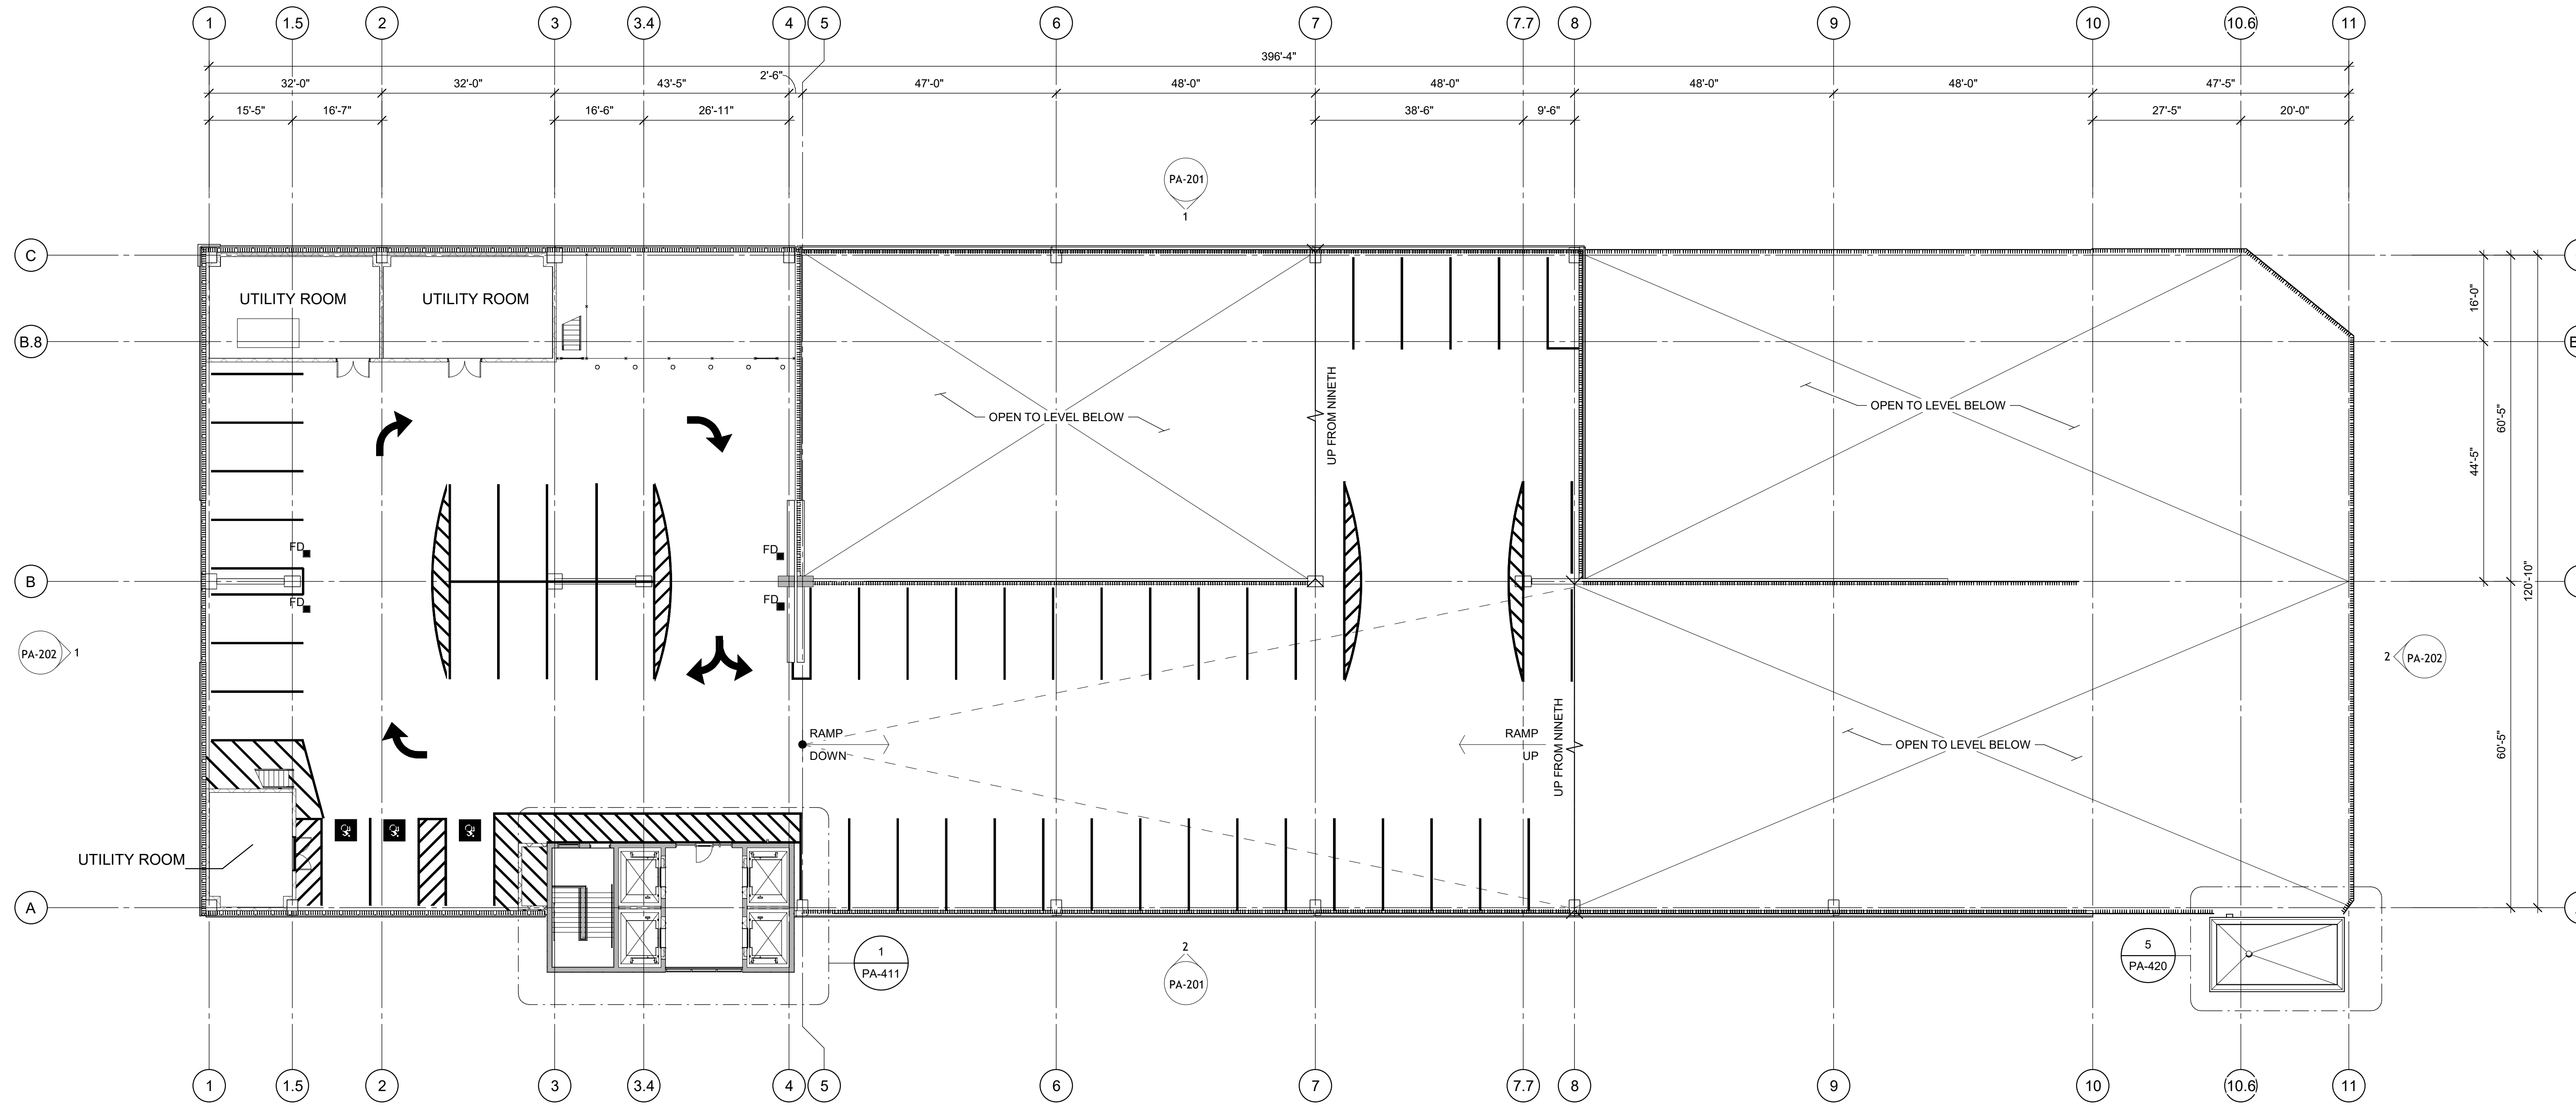

1 TOP TIER PLAN  
1/16" = 1'-0"

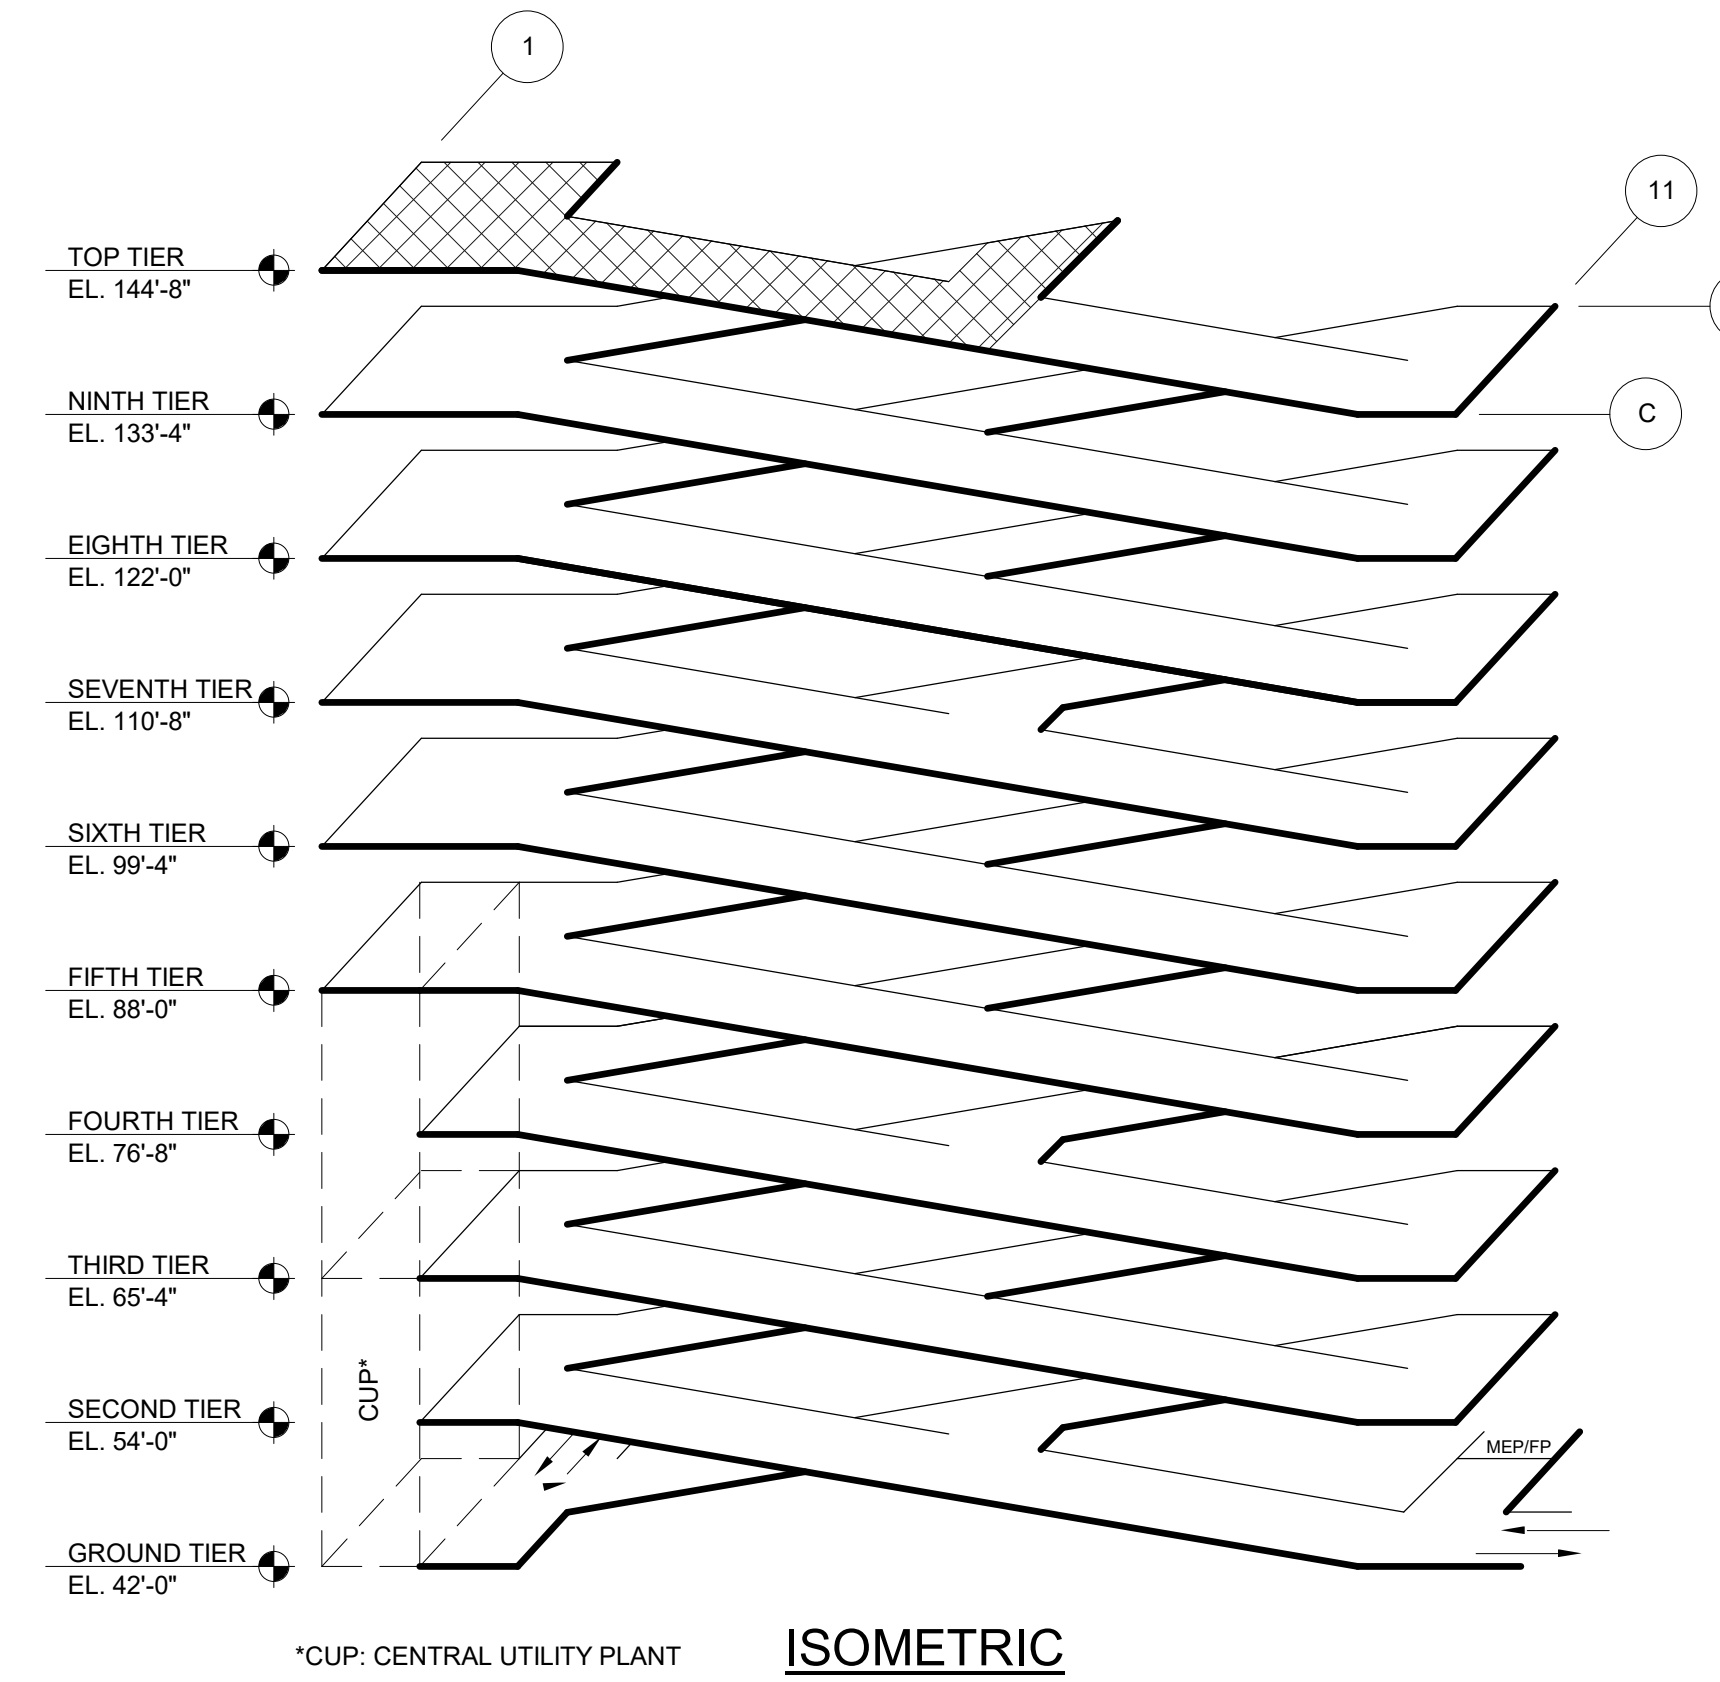

## SHEET NOTES

1. SEE SHEET PA-100 FOR TYPICAL SHEET NOTES AND LOCATIONS OF TYPICAL DETAIL REFERENCES, UN.




49 West 38th St, 9th Floor  
New York, NY 10018  
212.286.2501 Ph  
www.walkerconsultants.com

SCOTT ASHLEY, PE  
EOR LICENSE NO: 24GE05535400

PRELIMINARY - DO NOT USE FOR CONSTRUCTION

## LEGEND

|  |                                    |
|--|------------------------------------|
|  | CIP                                |
|  | CIP (PLAN CUT)                     |
|  | PRECAST CONCRETE                   |
|  | CMU                                |
|  | CIP POUR STRIP                     |
|  | TRAFFIC TOPPING                    |
|  | PAVEMENT MARKING - NO PARKING AREA |
|  | SHEET NOTE                         |
|  | FIRE EXTINGUISHER CABINET          |
|  | PIPE BOLLARD                       |
|  | SIGN LEGEND                        |
|  | FLOOR DRAIN                        |
|  | FLEXIBLE DELINEATOR POST           |
|  | EMERGENCY CALL STATION             |

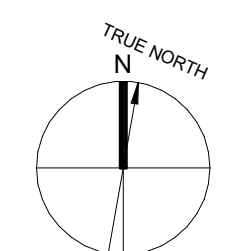

JSUMC-Neptune Garage  
Jersey Shore University  
Medical Center  
81 DAVIS AVENUE  
TOWNSHIP OF NEPTUNE  
MONMOUTH COUNTY, NJ

| MARK      | DATE       | DESCRIPTION    |
|-----------|------------|----------------|
| REVISIONS |            |                |
| 1         | 02/06/2025 | PLANNING BOARD |


ISSUE DATE: 02/06/2025  
PROJECT NO: 18-002290.00  
DRAWN BY: C.LUIS  
CHECKED BY: L.GE

COPYRIGHT © 2024. ALL RIGHTS RESERVED. NO PART OF THIS DOCUMENT MAY BE REPRODUCED IN ANY FORM OR BY ANY MEANS WITHOUT PERMISSION FROM WALKER CONSULTANTS.


SHEET TITLE:  
TOP TIER PLAN

PA-110

2/2/2025 3:01:30 PM Autodesk Docs://18-002290.00 JSUMC-Neptune Design-Build/2290\_NJ\_Neptune\_Garage\_Struct\_R04.rvt

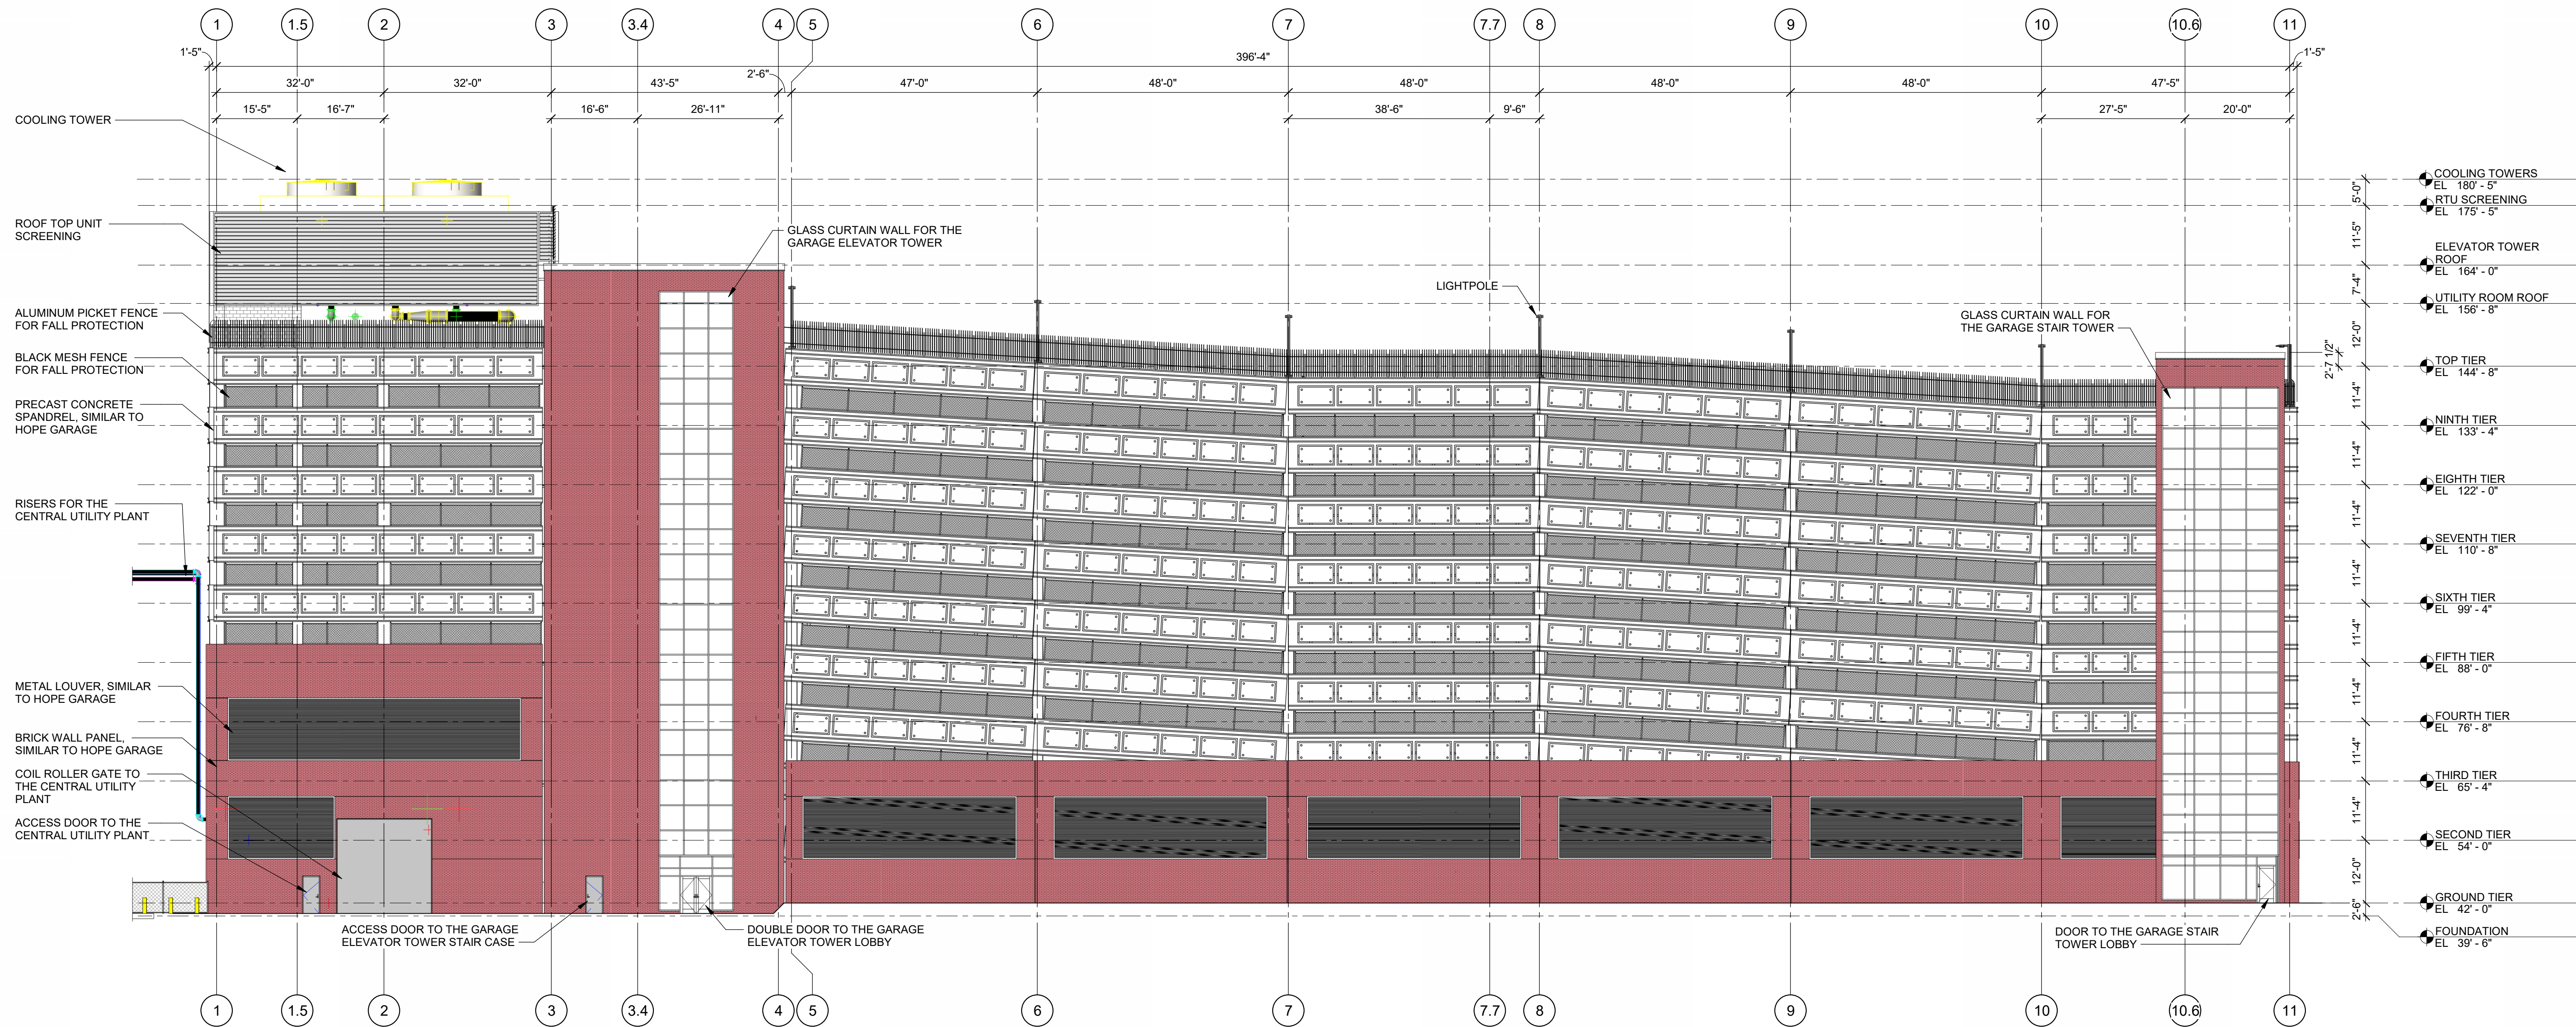

2 SOUTH ELEVATION  
1/16" = 1'-0"

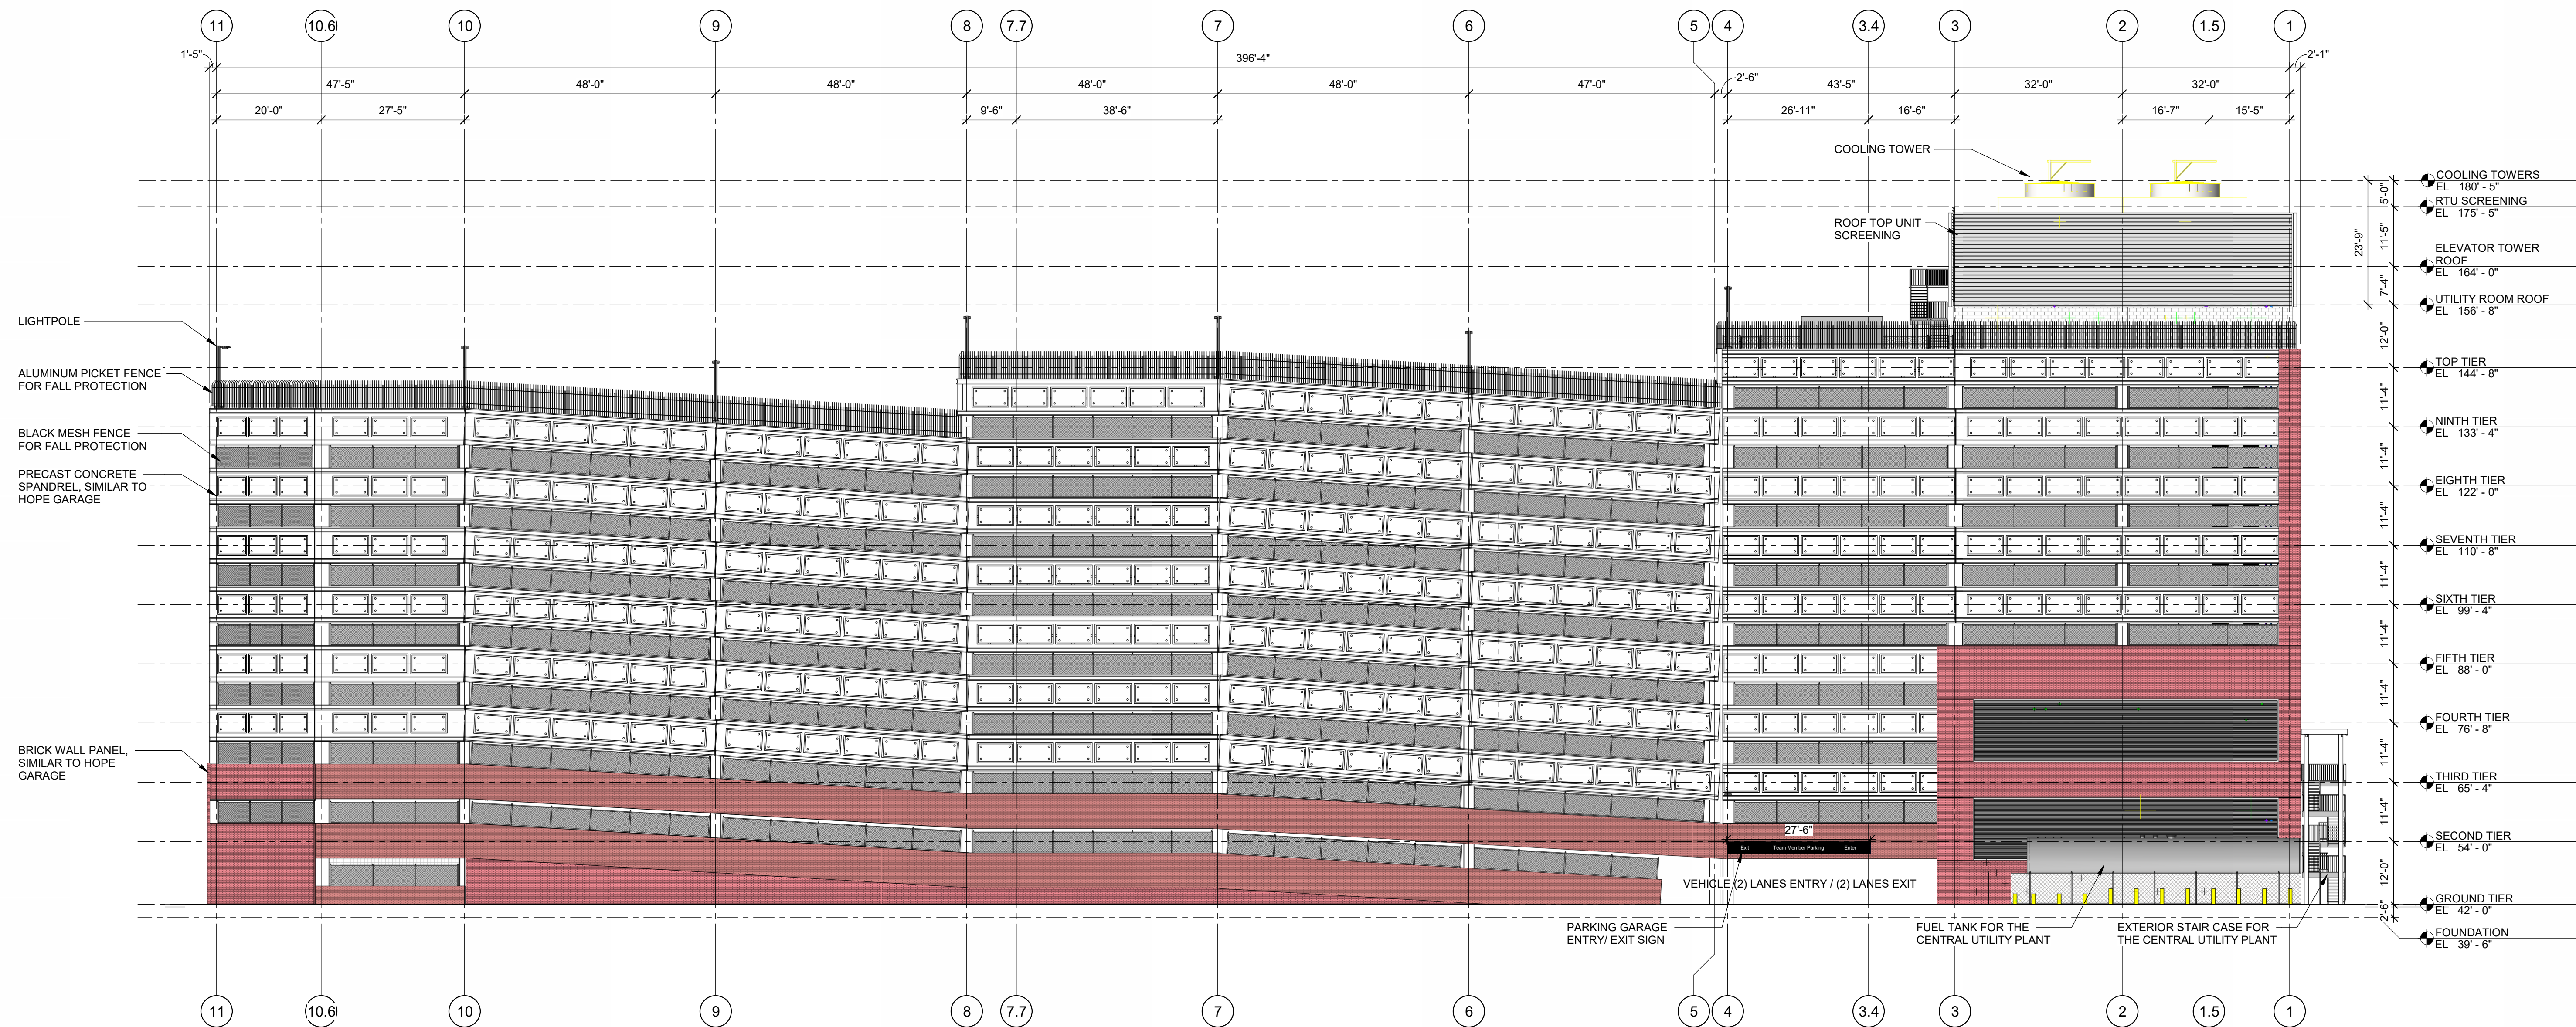

1 NORTH ELEVATION  
1/16" = 1'-0"

## SHEET NOTES



49 West 38th St, 9th Floor  
New York, NY 10018  
212.286.2501 Ph  
www.walkerconsultants.com

SCOTT ASHLEY, PE  
EOR LICENSE NO: 24GE05535400

PRELIMINARY - DO NOT USE FOR CONSTRUCTION

JSUMC-Neptune Garage  
Jersey Shore University  
Medical Center  
81 DAVIS AVENUE  
TOWNSHIP OF NEPTUNE  
MONMOUTH COUNTY, NJ

## LEGEND

- CIP
- CIP (PLAN CUT)
- PRECAST CONCRETE
- CMU
- CONCRETE WASH ON PRECAST CONCRETE
- CIP POUR STRIP
- TRAFFIC TOPPING
- SHEET NOTE


| MARK        | DATE           | DESCRIPTION |
|-------------|----------------|-------------|
| REVISIONS   |                |             |
| ISSUE:      | PLANNING BOARD |             |
| ISSUE DATE: | 02/06/2025     |             |
| PROJECT NO: | 18-002290.00   |             |
| DRAWN BY:   | C.LUIS         |             |
| CHECKED BY: | L.G.E          |             |

COPYRIGHT © 2024. ALL RIGHTS RESERVED. NO PART OF THIS DOCUMENT MAY BE REPRODUCED IN ANY FORM OR BY ANY MEANS WITHOUT PERMISSION FROM WALKER CONSULTANTS.

SHEET TITLE  
BUILDING ELEVATIONS

PA-201


2/5/2025 3:01:37 PM Autodesk Docs://18-002290.00 JSUMC-Neptune Design-Build#2290\_NJ\_Neptune\_Garage\_Struct\_R04.rvt

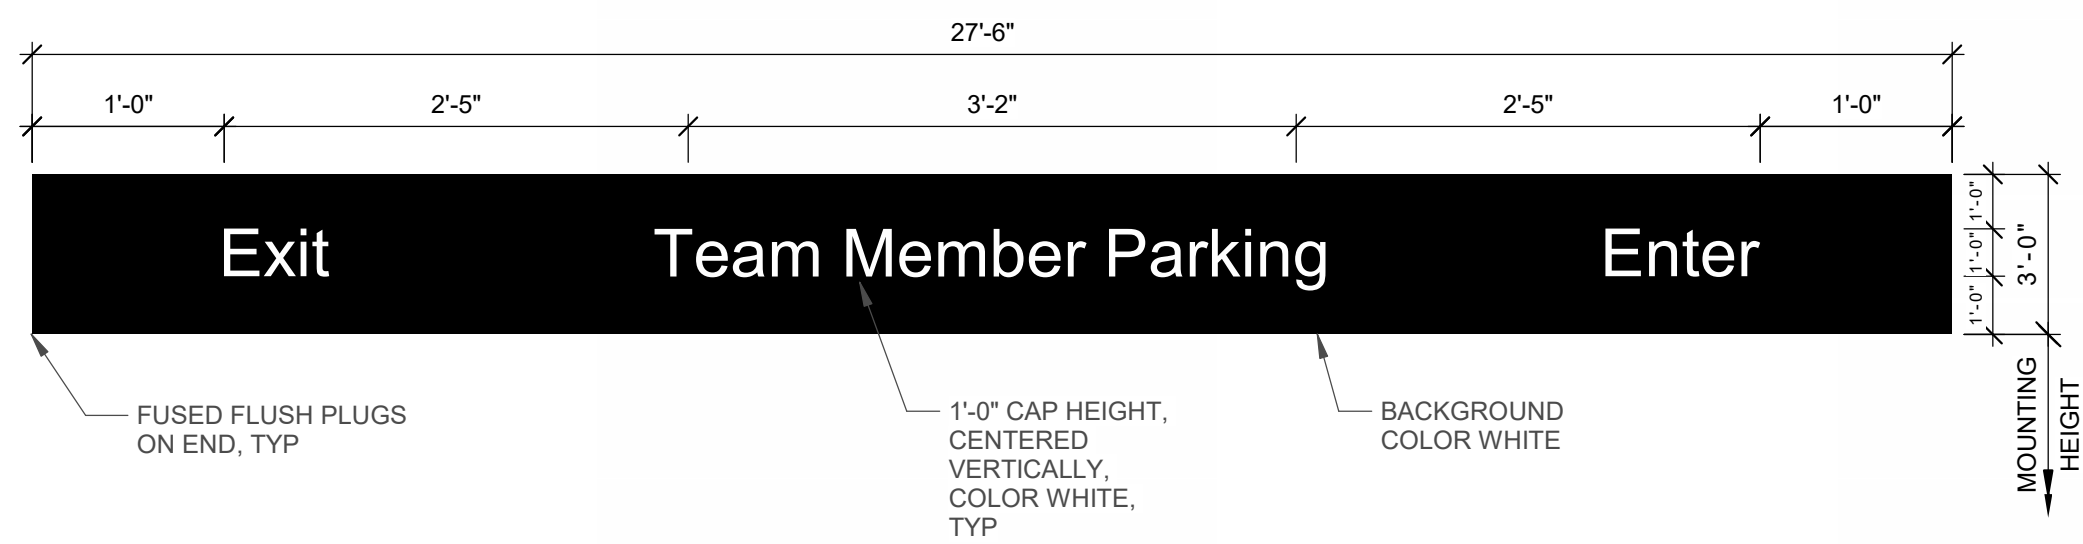

3 ENTRANCE SIGN DETAIL



2 EAST ELEVATION  
1/16" = 1'-0"

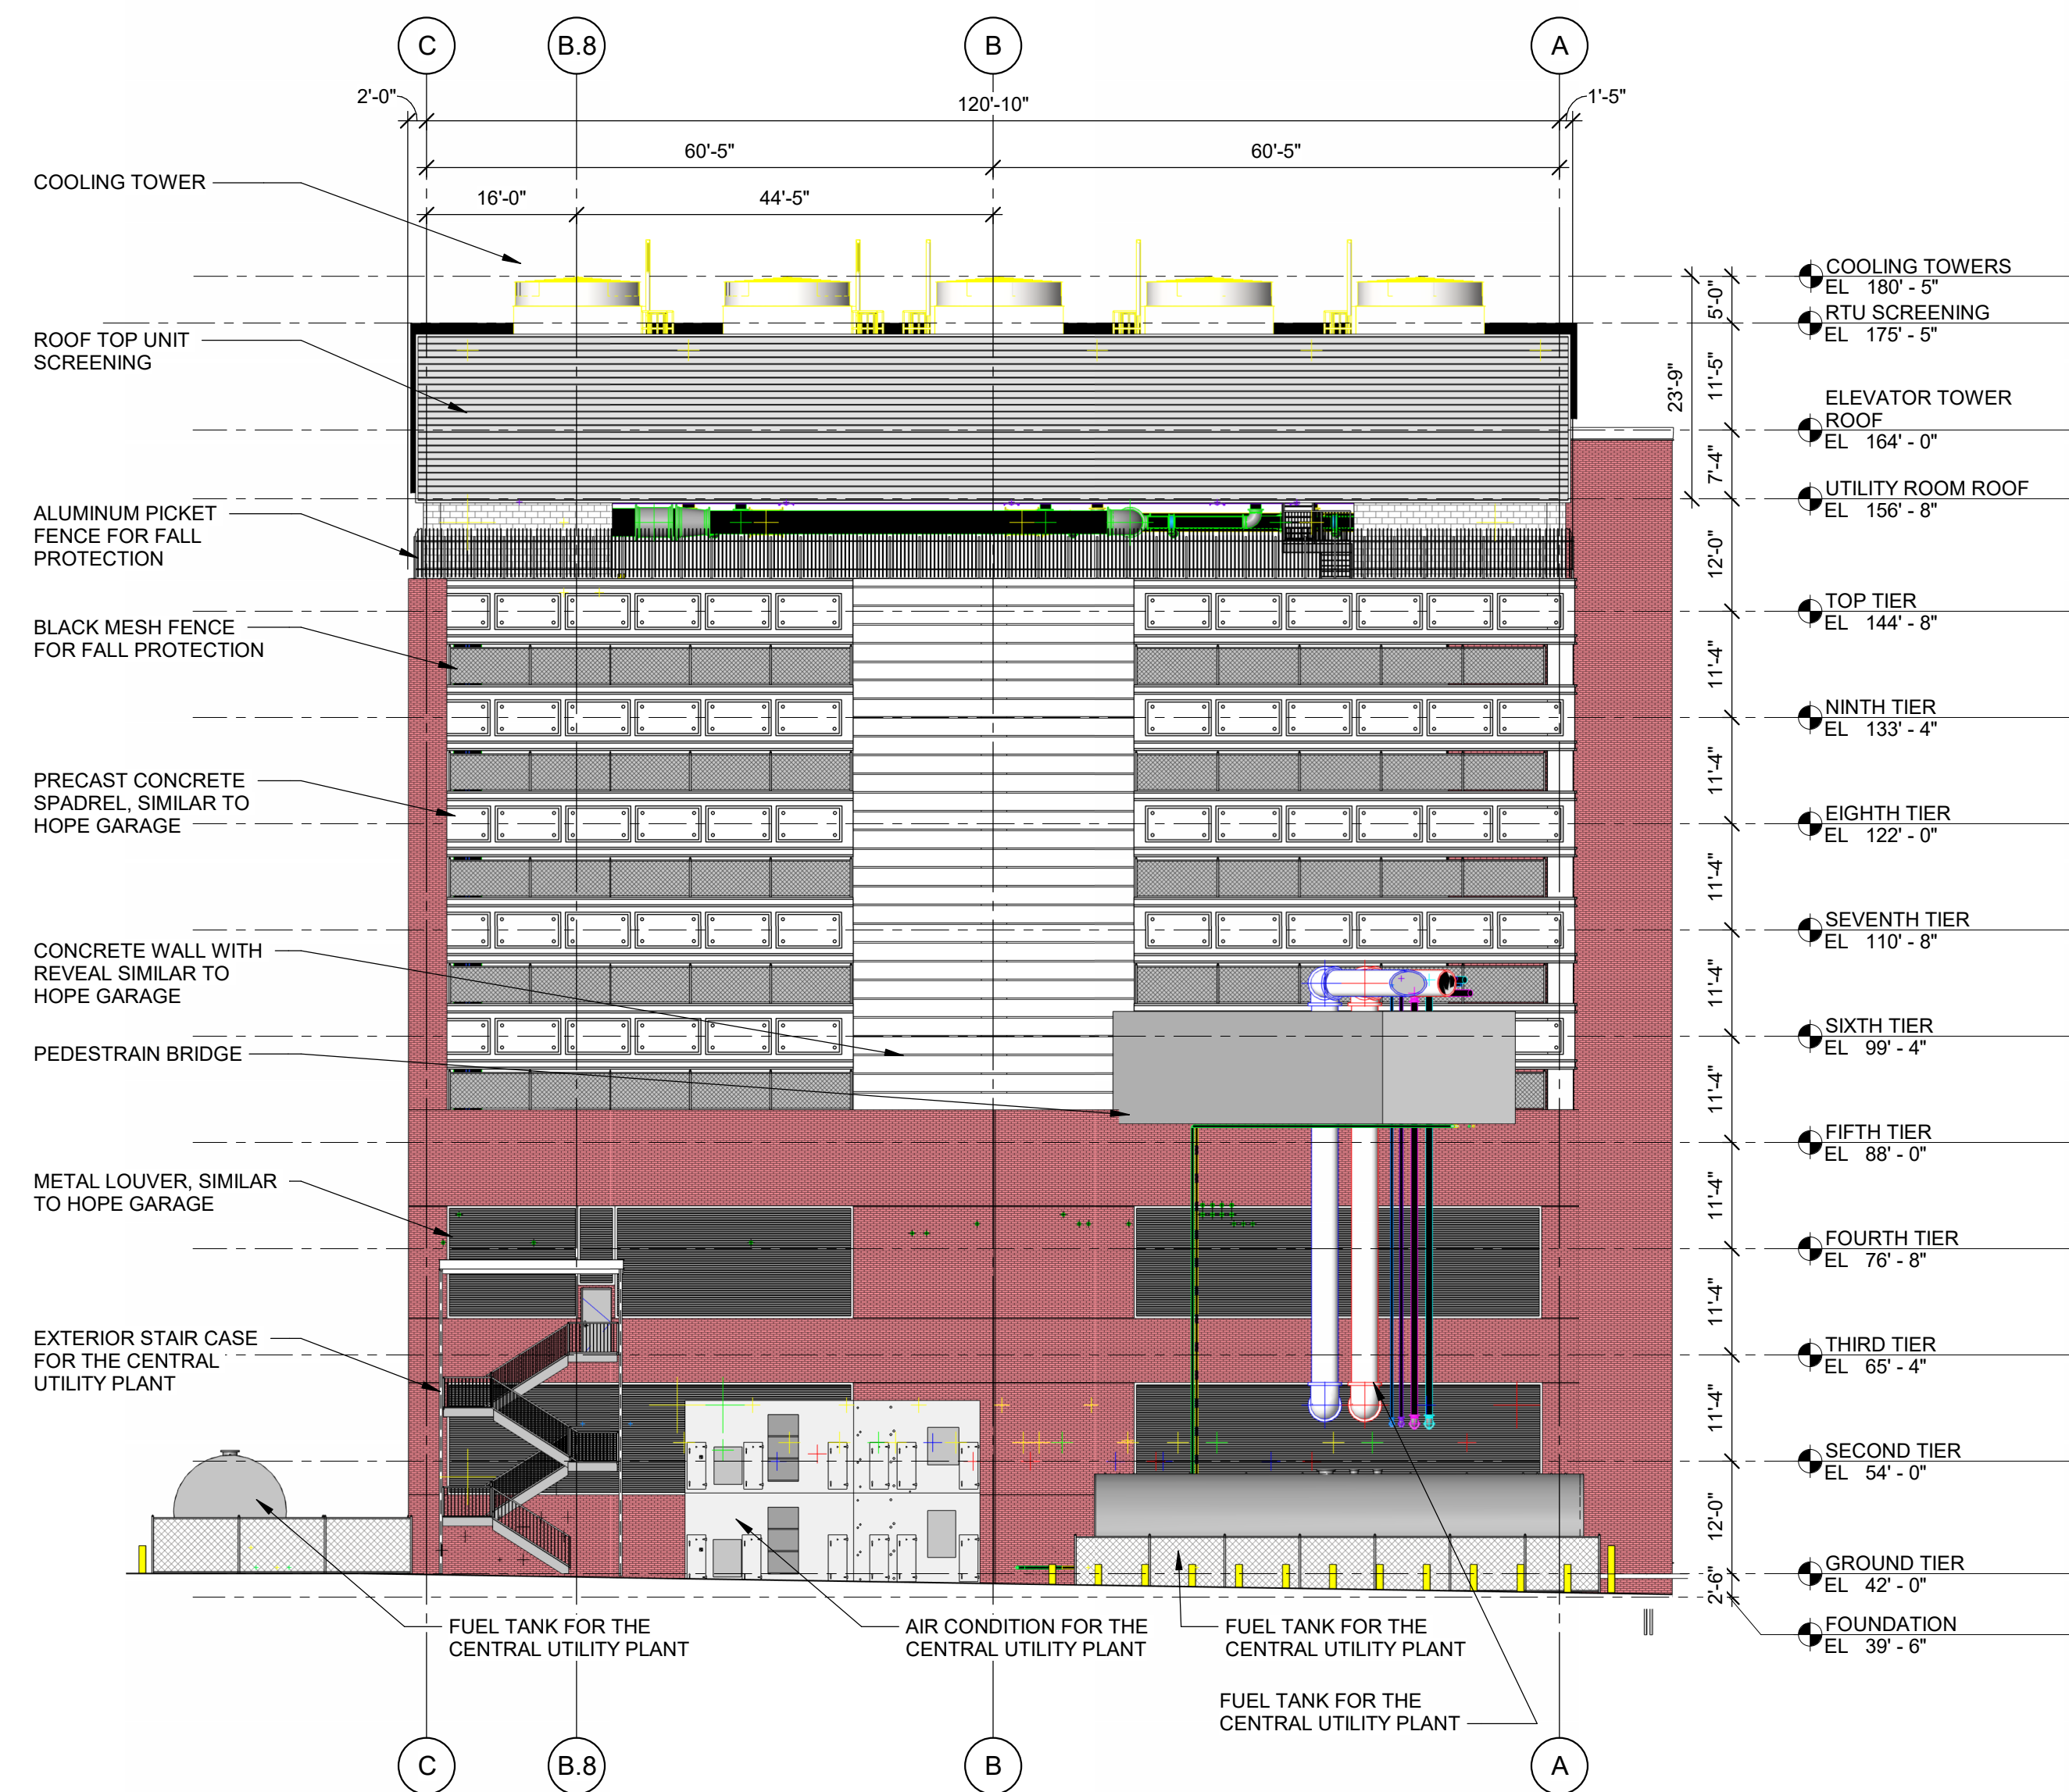

1 WEST ELEVATION  
1/16" = 1'-0"

SHEET NOTES



49 West 38th St, 9th Floor  
New York, NY 10018  
212.286.2501 Ph  
www.walkerconsultants.com

SCOTT ASHLEY, PE  
EOR LICENSE NO: 24GE05535400

PRELIMINARY - DO NOT USE FOR CONSTRUCTION

LEGEND

- CIP
- CIP (PLAN CUT)
- PRECAST CONCRETE
- CMU
- CONCRETE WASH ON PRECAST CONCRETE
- CIP POUR STRIP
- TRAFFIC TOPPING
- SHEET NOTE


JSUMC-Neptune Garage  
Jersey Shore University  
Medical Center  
81 DAVIS AVENUE  
TOWNSHIP OF NEPTUNE  
MONMOUTH COUNTY, NJ

| MARK                     | DATE | DESCRIPTION |
|--------------------------|------|-------------|
| REVISIONS                |      |             |
| PLANNING BOARD           |      |             |
| ISSUE DATE: 02/06/2025   |      |             |
| PROJECT NO: 18-002290.00 |      |             |
| DRAWN BY: C.LUIS         |      |             |
| CHECKED BY: L.GE         |      |             |

COPYRIGHT © 2024. ALL RIGHTS RESERVED. NO PART OF THIS DOCUMENT MAY BE REPRODUCED IN ANY FORM OR BY ANY MEANS WITHOUT PERMISSION FROM WALKER CONSULTANTS.

SHEET TITLE  
BUILDING ELEVATIONS

C:\REVIT PROJECTS\18-002290.00 NEPTUNE GARAGE DESIGN\DWG 2162025 11:19:57 AM BADALAN.EDGAR

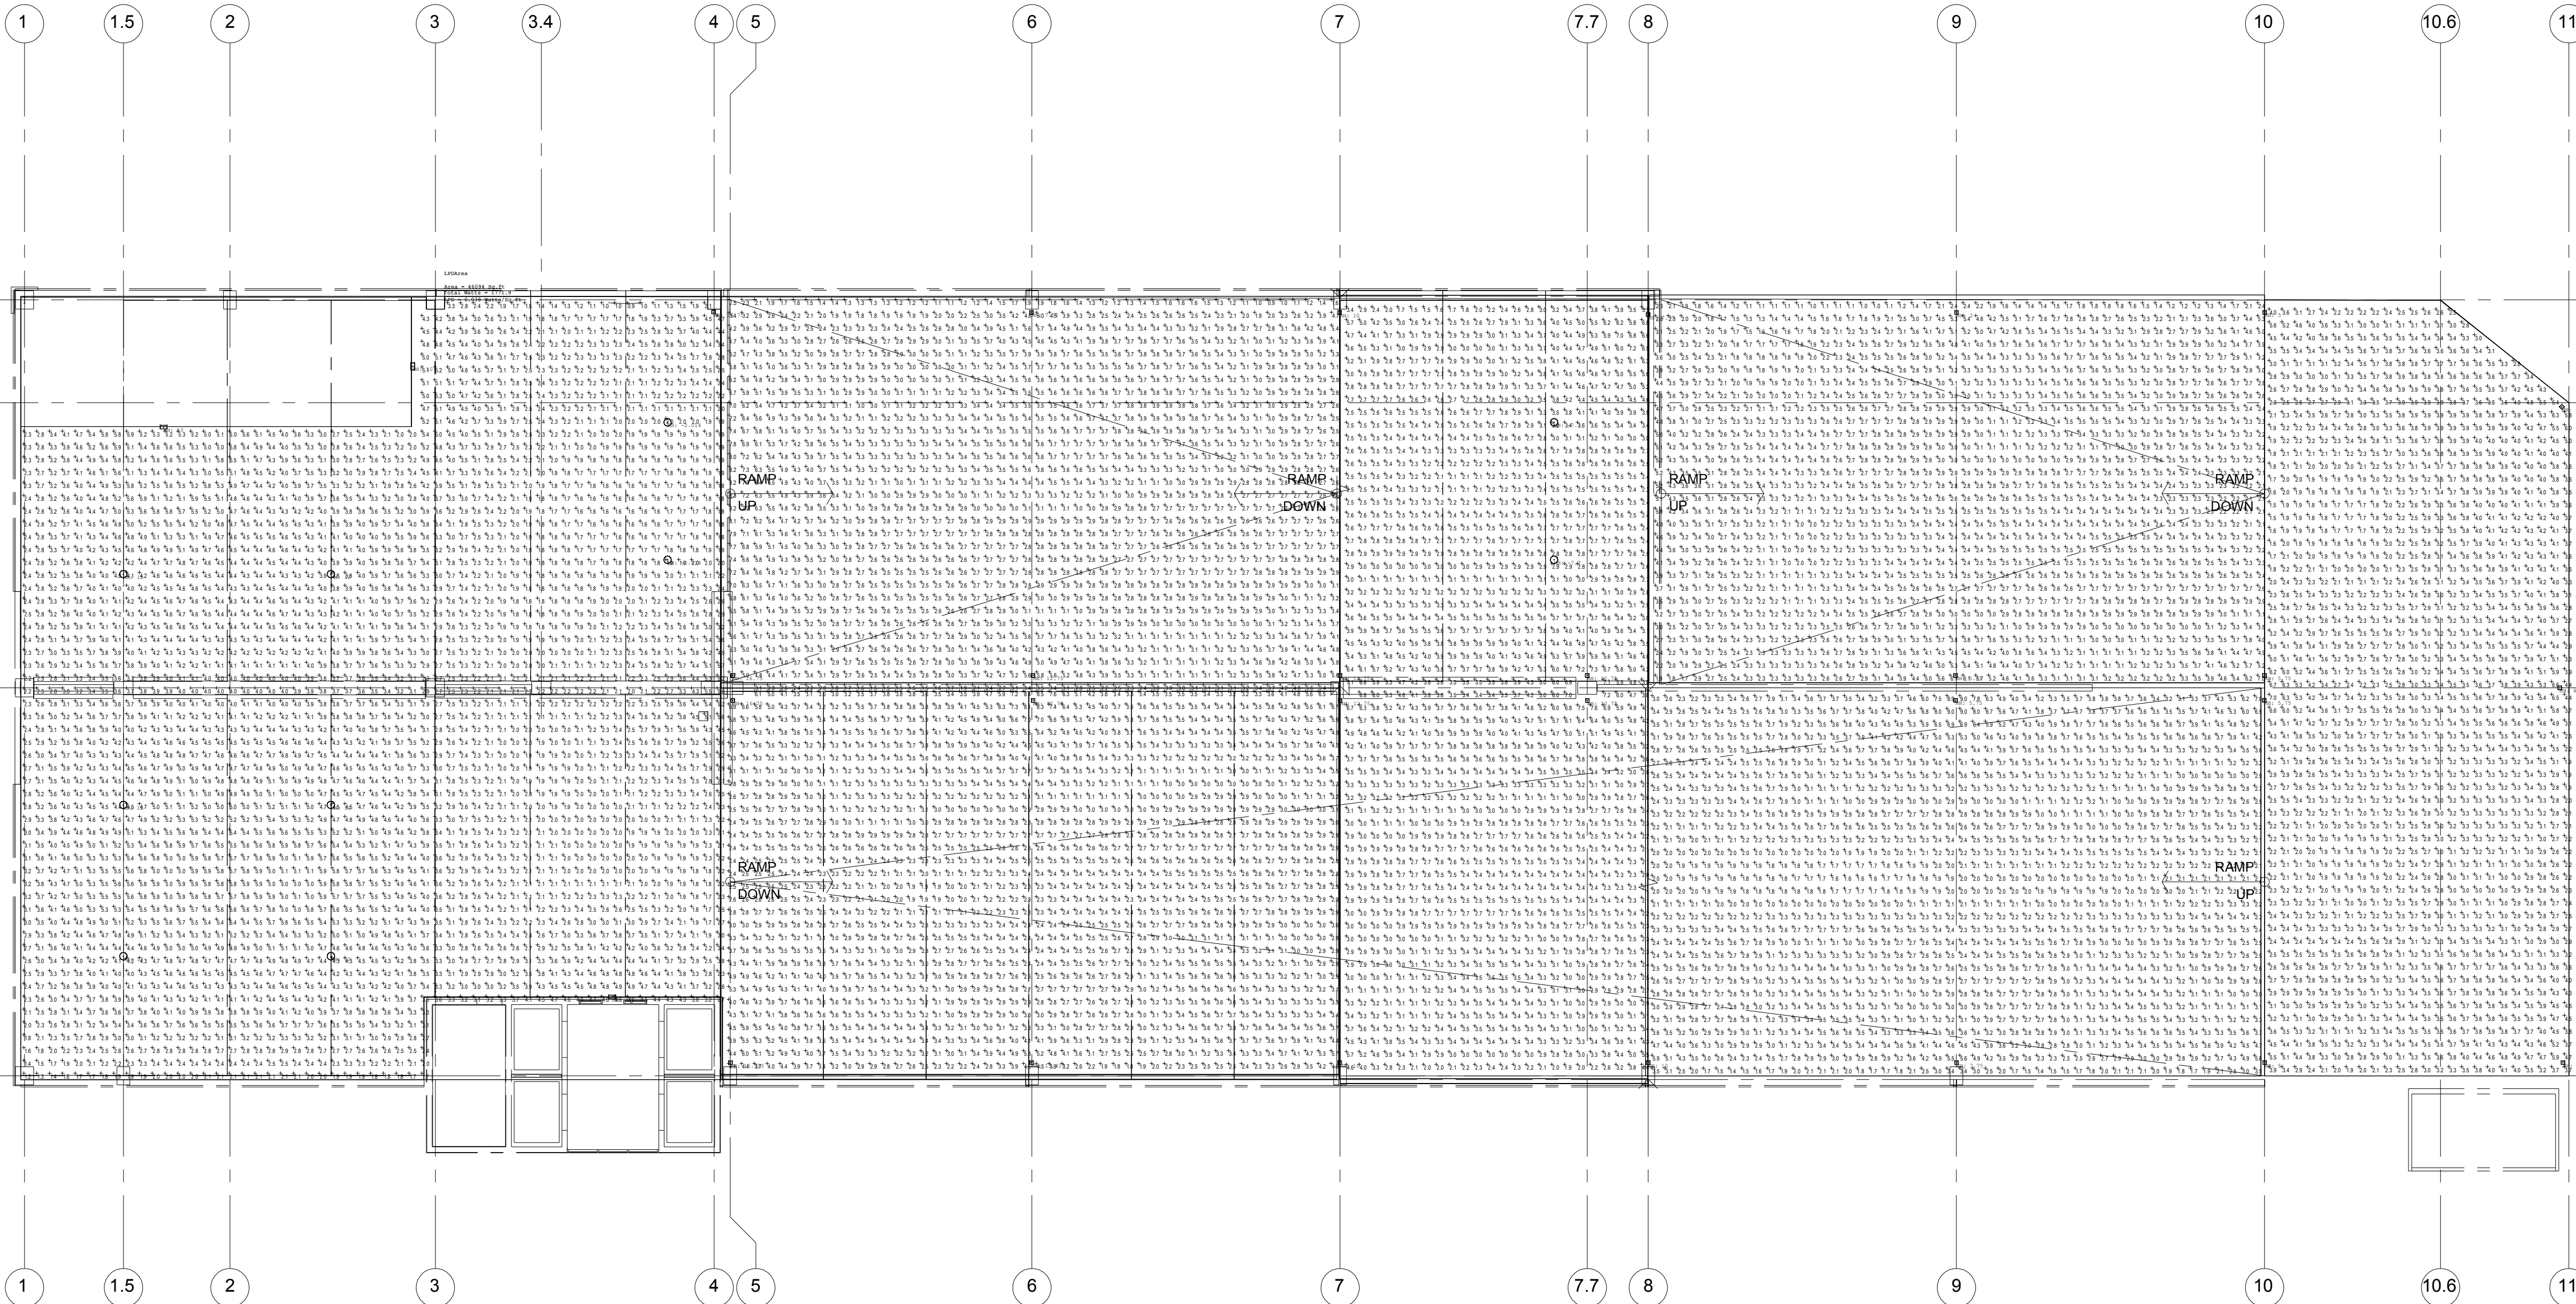

| Calculation Summary |             |       |      |     |     |         |         |
|---------------------|-------------|-------|------|-----|-----|---------|---------|
| Label               | CalcType    | Units | Avg  | Max | Min | Avg/Min | Max/Min |
| RAMP 2 Top          | Illuminance | Fc    | 3.13 | 7.0 | 1.5 | 2.09    | 4.67    |
| RAMP 4 1 Top        | Illuminance | Fc    | 3.26 | 7.6 | 1.5 | 2.17    | 5.07    |
| RAMP 4 1 Top 1      | Illuminance | Fc    | 2.77 | 7.0 | 1.0 | 2.77    | 7.00    |
| RAMP 6 Top 1        | Illuminance | Fc    | 2.91 | 9.0 | 1.4 | 2.08    | 6.43    |
| RAMP 8 2 Top        | Illuminance | Fc    | 3.30 | 8.3 | 0.9 | 3.67    | 9.22    |
| RAMP 8 Top          | Illuminance | Fc    | 3.20 | 8.5 | 1.8 | 1.78    | 4.72    |
| TOP_RAMP_Top        | Illuminance | Fc    | 3.45 | 6.6 | 0.9 | 3.83    | 7.33    |

| LPD Area Summary |       |             |       |
|------------------|-------|-------------|-------|
| Label            | Area  | Total Watts | LPD   |
| LPDArea          | 46094 | 1771.9      | 0.038 |

| Luminaire Schedule |     |                               |             |                         |       |                  |                 |             |                                                          |
|--------------------|-----|-------------------------------|-------------|-------------------------|-------|------------------|-----------------|-------------|----------------------------------------------------------|
| Symbol             | Qty | Label                         | Arrangement | Description             | LLF   | Luminaire Lumens | Luminaire Watts | Total Watts | [MANUFAC]                                                |
| □                  | 2   | GLAN-SA1A-740-U-SLR 3989 lume | Single      | GLAN-SA1A-740-U-SLR     | 0.880 | 3989             | 33              | 66          | COOPER LIGHTING SOLUTIONS - STREETWORKS (FORMERLY EATON) |
| □                  | 1   | GLAN-SA1A-740-U-SLL-HSS 3323  | Single      | GLAN-SA1A-740-U-SLL-HSS | 0.880 | 3323             | 33              | 33          | COOPER LIGHTING SOLUTIONS - STREETWORKS (FORMERLY EATON) |
| □                  | 12  | GLAN-SA1B-740-U-SL3-HSS 4763  | Single      | GLAN-SA1B-740-U-SL3-HSS | 0.880 | 4763             | 44              | 528         | COOPER LIGHTING SOLUTIONS - STREETWORKS (FORMERLY EATON) |
| □                  | 12  | GLAN-SA1B-740-U-SL3 3767 lume | Single      | GLAN-SA1B-740-U-SL3     | 0.880 | 3767             | 44              | 528         | COOPER LIGHTING SOLUTIONS - STREETWORKS (FORMERLY EATON) |
| □                  | 3   | CCW-VA-3-740-U-T2             | Single      | CCW-VA-3-740-U-T2       | 0.870 | 4423             | 48.3            | 144.9       | COOPER LIGHTING SOLUTIONS - INVUE (FORMERLY EATON)       |
| □                  | 10  | TT-D3-740-U-WQ                | Single      | TT-D3-740-U-WQ          | 0.870 | 6359             | 47.2            | 472         | EATON - MCGRAW-HILL (FORMER COOPER LIGHTING)             |

## SHEET NOTES



49 West 38th St. 9th Floor  
New York, NY 10018  
212.288.2501 Ph  
www.walkerconsultants.com


SCOTT ASHLEY, PE  
EOR LICENSE NO: 24GE0535400

PRELIMINARY - DO NOT USE FOR CONSTRUCTION

JSUMC-Neptune Garage  
Jersey Shore University  
Medical Center  
81 DAVIS AVENUE  
TOWNSHIP OF NEPTUNE  
MONMOUTH COUNTY, NJ

## LEGEND

- CIP
- CIP (PLAN CUT)
- PRECAST CONCRETE
- CMU
- CIP POUR STRIP
- TRAFFIC TOPPING
- PAVEMENT MARKING - NO PARKING
- SHEET NOTE

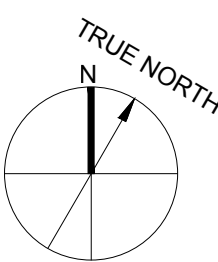

| MARK      | DATE | DESCRIPTION    |
|-----------|------|----------------|
| REVISIONS |      |                |
| 1         |      | PLANNING BOARD |

ISSUE DATE: 02/05/2025  
PROJECT NO: 18-002290.00  
DRAWN BY: DN  
CHECKED BY: JLE

COPYRIGHT © 2024. ALL RIGHTS RESERVED. NO PART OF THIS DOCUMENT MAY BE REPRODUCED IN ANY FORM OR BY ANY MEANS WITHOUT PERMISSION FROM WALKER CONSULTANTS.

SHEET TITLE:  
TOP TIER LIGHTING ANALYSIS

PLS-110