


1 ELEVATION - NORTH
SCALE: 1/4" = 1'-0"

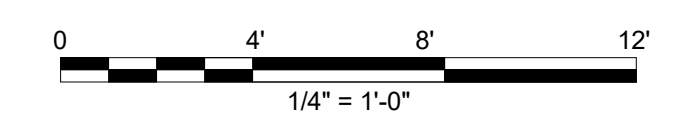

Jacobs
JACOBS ENGINEERING GROUP INC.
412 MOUNT KEMBLE AVE.
MORRISTOWN, NJ 07960
NJCA 246A27990200

REVISIONS		REVISIONS	
△ 0	ISSUED FOR 60% MR 08/22/2023	△	
△		△	
△		△	
△		△	
△		△	



Approver
[Signature]
Joseph Bongiovanni
GE43774

AMERICAN WATER ENGINEERING
1 WATER STREET
CAMDEN, NJ 08102
NEW JERSEY AMERICAN WATER
DRAWN BY MR PROJECT ENGR JB
DATE 08/22/2023
PROJECT 118-180101

JUMPING BROOK CHLORINE CONVERSION PROJECT		
ARCHITECTURAL EXTERIOR ELEVATIONS		
NEW JERSEY AMERICAN	60% DESIGN	USE DIMENSIONS ONLY SCALE 1/4" = 1'-0" A-200
USE APPROVED DRAWINGS ONLY FOR CONSTRUCTION PURPOSES		